



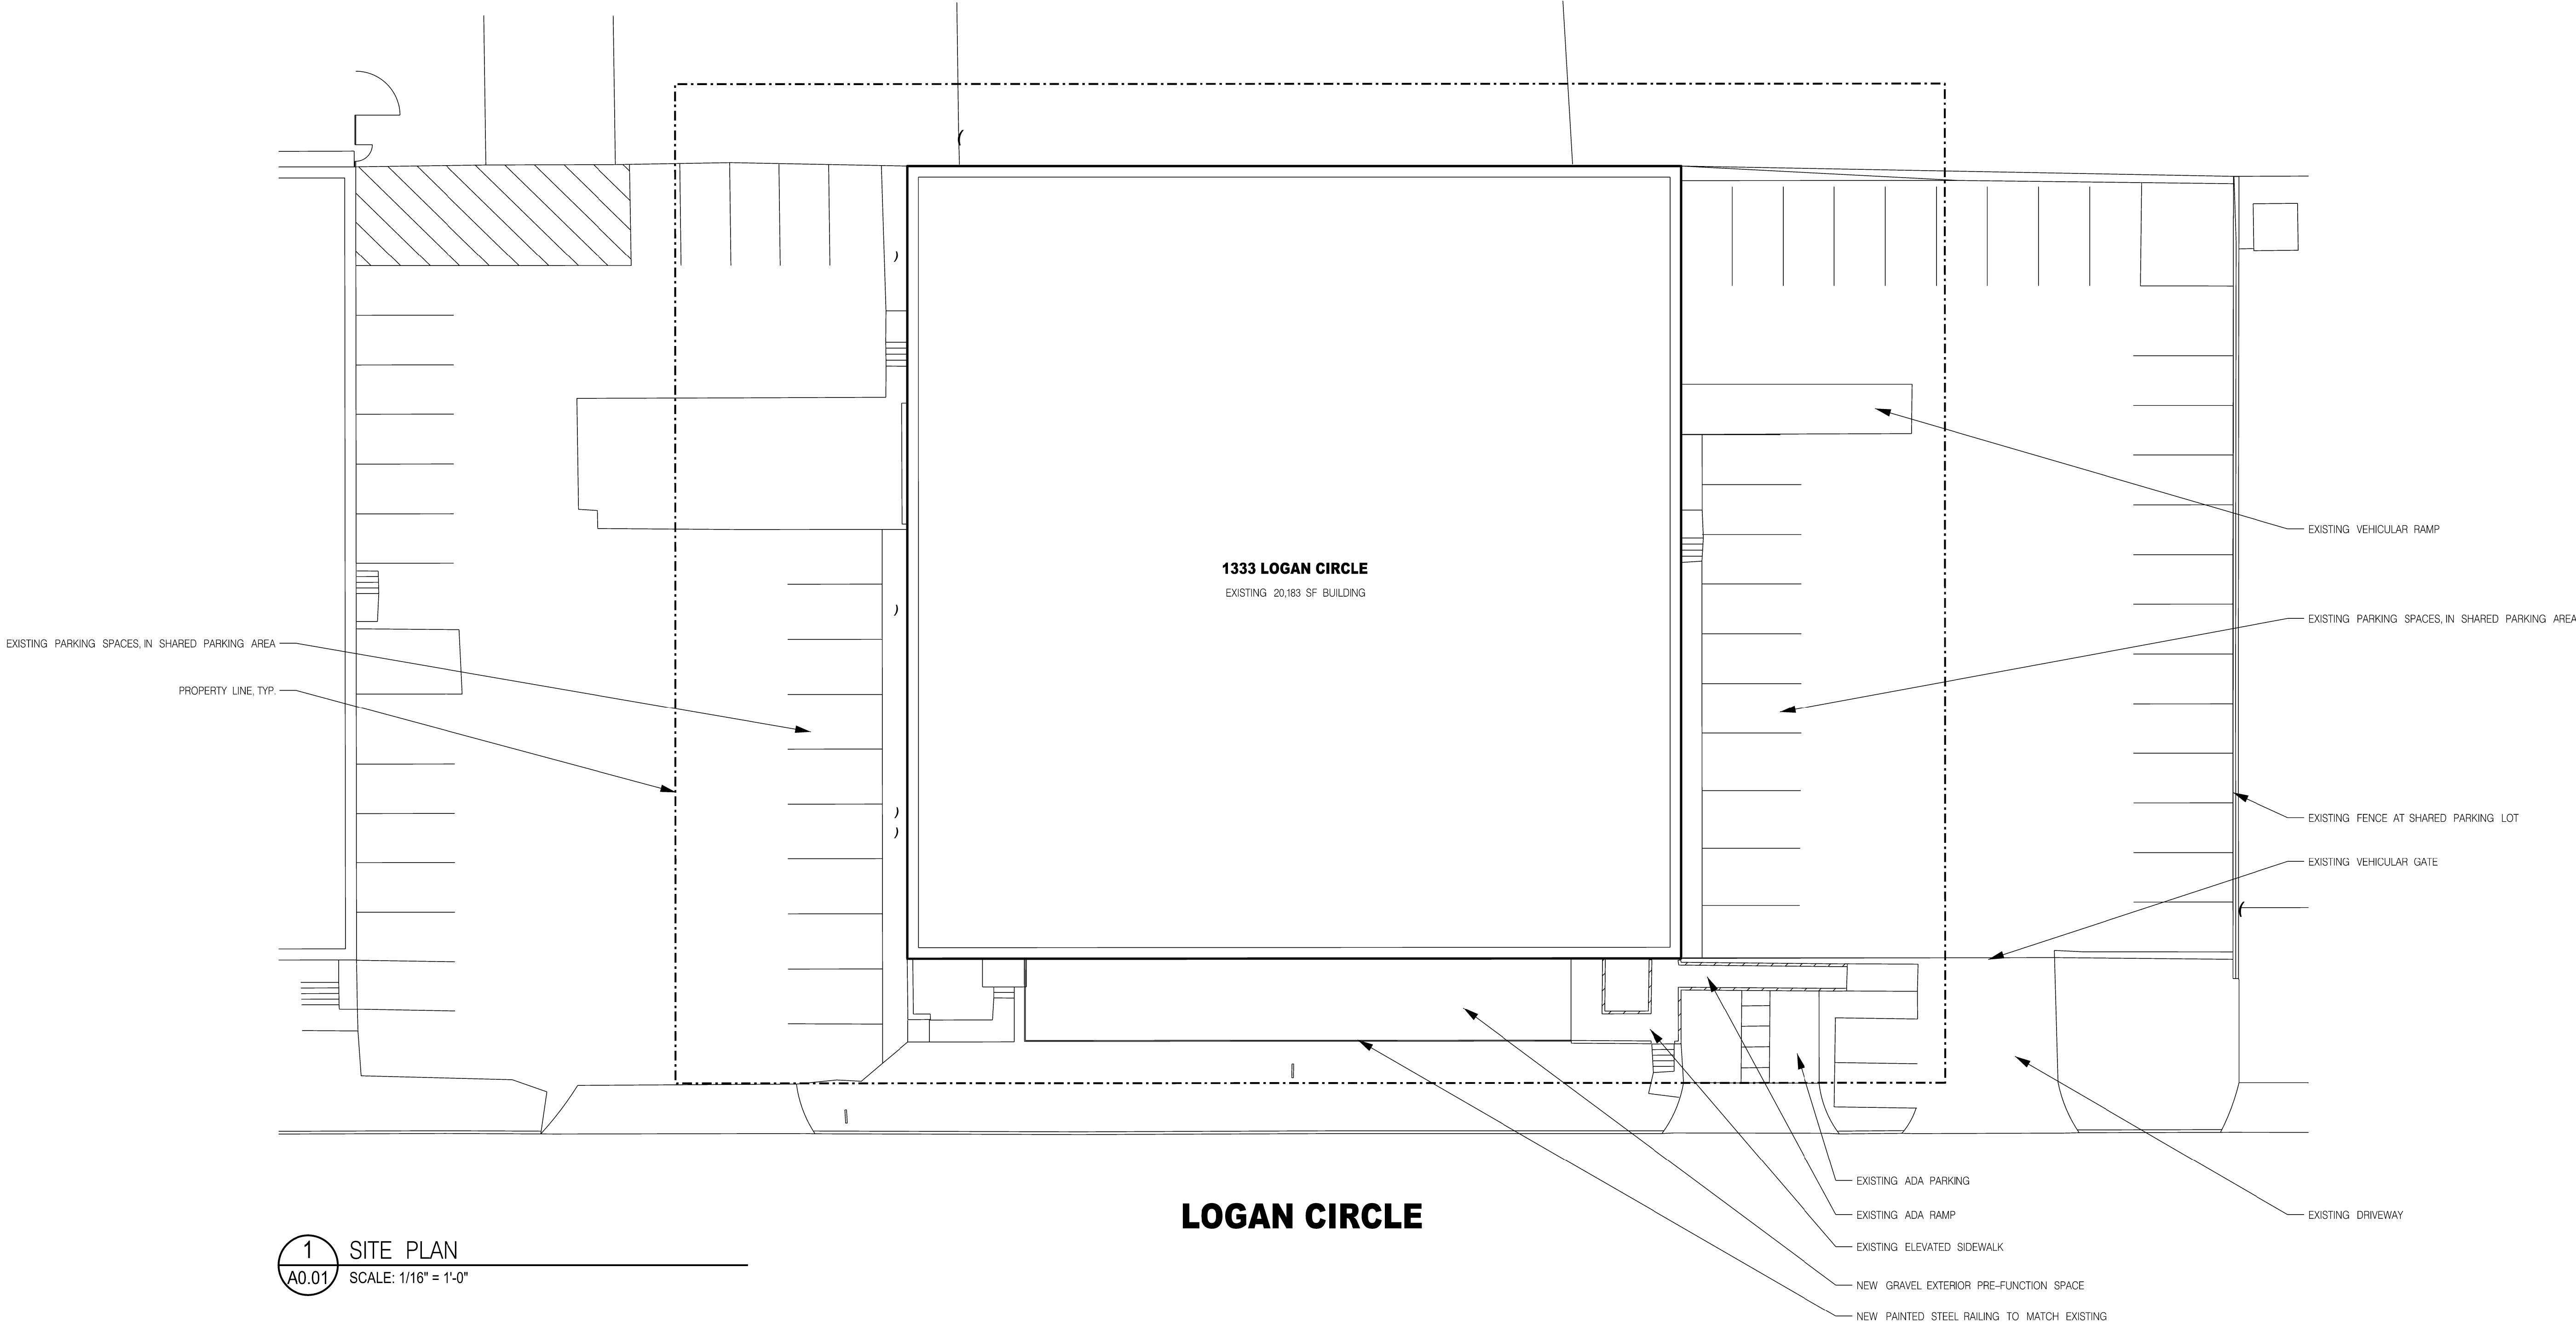

1 SITE PLAN
A0.01 SCALE: 1/16" = 1'-0"


A0.01
SITE PLAN
1/16" = 1'-0"

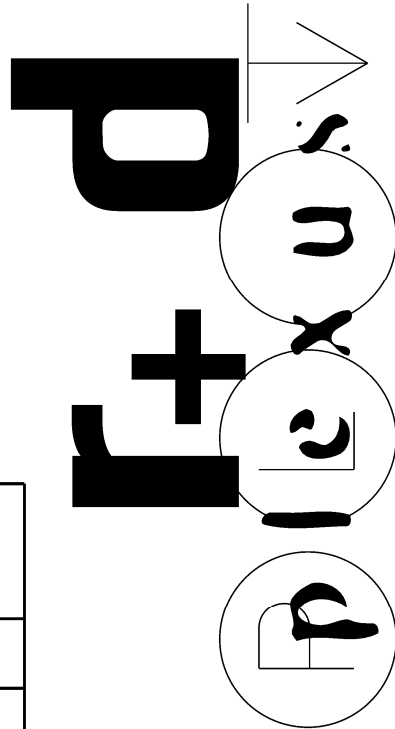

plexus r + d, inc.
914 Howell Mill Road, Suite 400 - Atlanta, Georgia 30318
404.519.7728 PHONE

© COPYRIGHT 2022 - PLEXUS R + D, INC.

ISSUED		
01/24/22 PRELIMINARY		
XX.XXXX PERMIT SET		
ONE STOP PRODUCTIONS 1333 Logan Circle NW Atlanta, GA 30318		Selig Enterprises 6595 ROSWELL ROAD, SUITE G ATLANTA, GA 30328
Project Number: 777.00		ISSUED FOR PERMIT & CONSTRUCTION
CONTRACTOR		
STRUCTURAL Kelly Albright PEC Structural Engineering 2752 East Ponce de Leon Ave Suite D Atlanta, Georgia 30030 404.660.6022		
M.E.P. & F.P. Westside Engineering 5525 Interstate North Parkway Suite 200 Atlanta, GA 30328 Phone: 404-242-6240		
CIVIL		

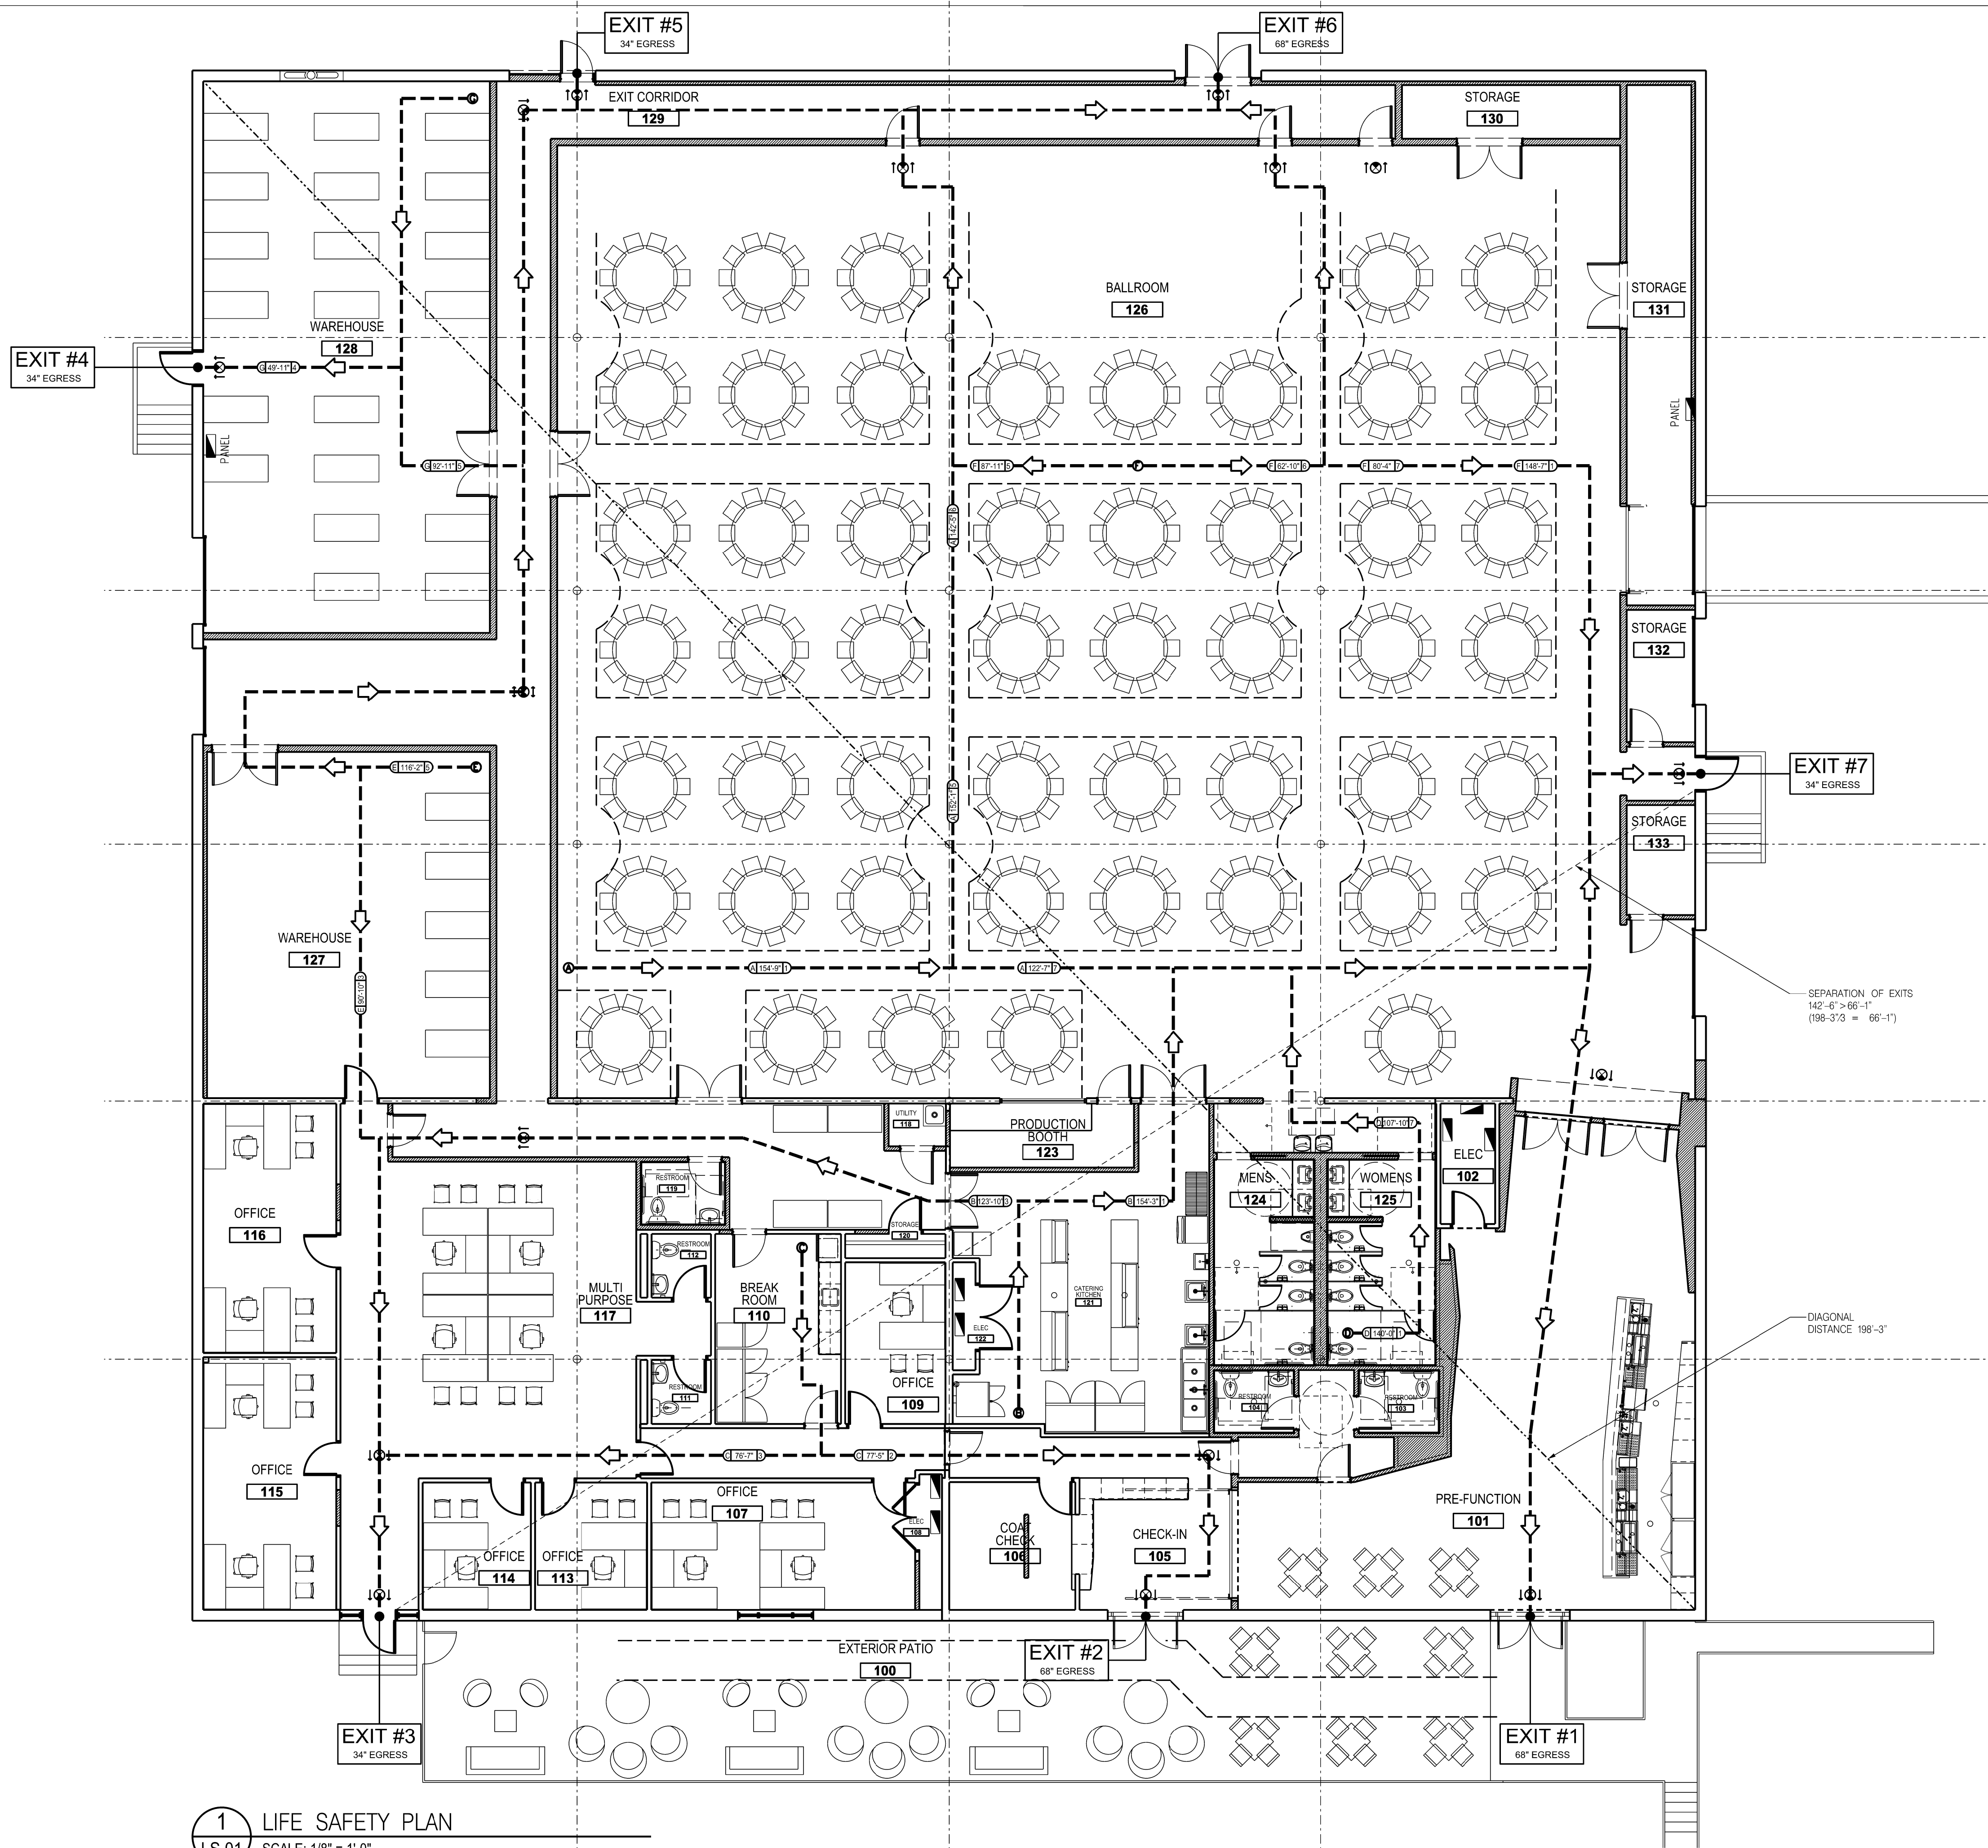

1 LIFE SAFETY PLAN
LS.01 SCALE: 1/8" = 1'-0"

L I F E S A F E T Y					
	ORIGIN POINT OF TRAVEL				
	POINT OF SAFETY				
	POINT OF CONTINUATION				
	PATH OF TRAVEL TO POINT OF SAFETY				
	WALL MOUNTED FIRE EXTINGUISHER - TYPE ABC (SPACING PER NFPA 10)				
	WALL MOUNTED FIRE EXTINGUISHER - TYPE K (SPACING PER NFPA 10)				
E X I T A R R A N G E M E N T					
USE GROUP OR SPACE	DIAGONAL DIMENSION OF SPACE	MAXIMUM ALLOWABLE TRAVEL DISTANCE	MINIMUM REQUIRED DISTANCE BETWEEN EXITS	ACTUAL DISTANCE BETWEEN EXITS	
ONE STOP A-2 BANQUET HALL	198'-3"	250' MAXIMUM ¹	66'-1" ²	142'-6"	
NOTES: 1 IBC 2018, TABLE 1017.2 (TRAVEL DISTANCE) 2 IBC 2018, 1007.1.1.(2) (EXIT ARRANGEMENT)					
E G R E S S C A P A C I T Y					
	ACTUAL OCCUPANTS PER EXIT		EXIT MAXIMUM CAPACITY		
EXIT 1	846 / 3 = 282 (TOTAL OCCUPANTS)		68" / 0.2 = 340		
EXIT 2	846 / 3 = 282 (TOTAL OCCUPANTS)		68" / 0.2 = 340		
EXIT 3	35 / 1 = 35 (BUSINESS AND KITCHEN ONLY)		34" / 0.2 = 170		
EXIT 4	5 / 1 = 5 (WAREHOUSE ONLY)		34" / 0.2 = 170		
EXIT 5	581 / 4 = 146 (BALLROOM ONLY)		34" / 0.2 = 170		
EXIT 6	581 / 4 = 146 (BALLROOM ONLY)		68" / 0.2 = 340		
EXIT 7	581 / 4 = 146 (BALLROOM ONLY)		34" / 0.2 = 170		
D E A D E N D C O R R I D O R					
IBC 2018, 1020.4 - DEAD END CORRIDORS SHALL NOT EXCEED 20 FT					
O C C U P A N C Y L O A D					
PER IBC 2018 TABLE 1004.5, AND 1004.6 FOR BOOTHS					
ROOM #	ROOM NAME	OCC. TYPE	TOTAL SF	REQ. SF / PERSON	# PEOPLE
101	PREFUNCTION	ASSEMBLY	667 SF	7 SF	96
102	ELEC	N/A	57 SF	-	-
103	RESTROOM	N/A	42 SF	-	-
104	RESTROOM	N/A	42 SF	-	-
105	CHECK IN	ASSEMBLY	167 SF	7 SF	24
106	COAT CHECK	BUSINESS	138 SF	100 SF	2
107	OFFICE	BUSINESS	289 SF	100 SF	3
108	ELEC	N/A	26 SF	-	-
109	OFFICE	BUSINESS	140 SF	100 SF	2
110	BREAKROOM	BUSINESS	206 SF	100 SF	3
111	RESTROOM	N/A	33 SF	-	-
112	RESTROOM	N/A	33 SF	-	-
113	OFFICE	BUSINESS	123 SF	100 SF	2
114	OFFICE	BUSINESS	118 SF	100 SF	2
115	OFFICE	BUSINESS	290 SF	100 SF	3
116	OFFICE	BUSINESS	286 SF	100 SF	3
117	MULTI PURPOSE	BUSINESS	806 SF	100 SF	9
118	UTILITY	N/A	25 SF	-	-
119	RESTROOM	N/A	44 SF	-	-
120	STORAGE	STORAGE	21 SF	500 SF	1
121	CATERING KITCHEN	KITCHEN	543 SF	200 SF	3
122	ELEC	N/A	21 SF	-	-
123	PRODUCTION BOOTH	BUSINESS	102 SF	100 SF	2
124	MENS RESTROOM	N/A	176 SF	-	-
125	WOMENS RESTROOM	N/A	189 SF	-	-
126	BALLROOM	LESS CONCENTRATED	8711 SF	15 SF	581
127	WAREHOUSE	STORAGE	843 SF	500 SF	2
128	WAREHOUSE	STORAGE	1361 SF	500 SF	3
129	EXIT CORRIDOR	N/A	1778 SF	-	-
130	STORAGE	STORAGE	121 SF	500 SF	2
131	STORAGE	STORAGE	234 SF	500 SF	3
132	STORAGE	STORAGE	78 SF	500 SF	1
133	STORAGE	STORAGE	65 SF	500 SF	1
				TOTAL INTERIOR	748
100	EXTERIOR PATIO	LESS CONCENTRATED	1,466 SF	15 SF	98
				TOTAL OCCUPANT LOAD 846	

LS.01
LIFE SAFETY PLAN
1/8" = 1'-0"

ISSUED
01/24/22 PRELIMINARY
XX XXXX PERMIT SET

ONE STOP PRODUCTIONS

1333 Logan Circle NW
Atlanta, GA 30318

Project Number: 777.00

ISSUED FOR
PERMIT & CONSTRUCTION

Selig Enterprises

6595 ROSWELL ROAD, SUITE G
ATLANTA, GA 30328

CONTRACTOR


STRUCTURAL


Kelly Allbright
PEC Structural Engineering
2752 East Ponce de Leon Ave
Suite D
Atlanta, Georgia 30030
404.660.6022

M.E.P. & F.P.


Westside Engineering
5525 Intestate North Parkway
Suite 200
Atlanta, GA 30328
Phone: 404-242-6240

CIVIL

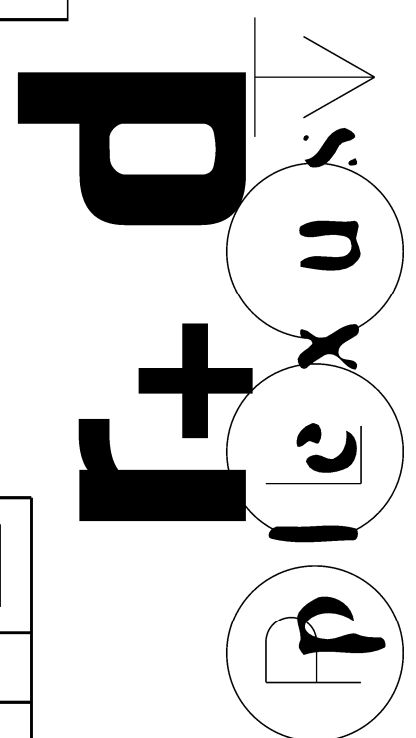

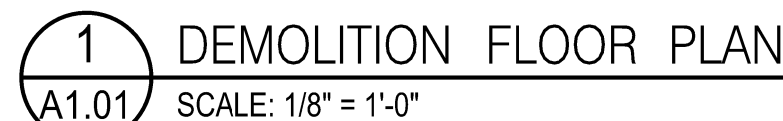

A1.01
DEMO PLAN
1/8" = 1'-0"

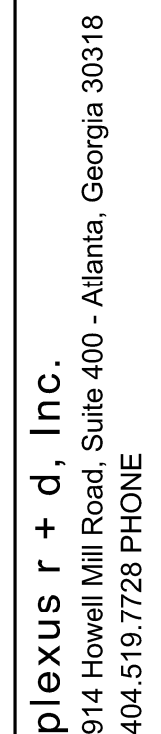





A1.02

FLOOR PLAN

1/8" = 1'-0"

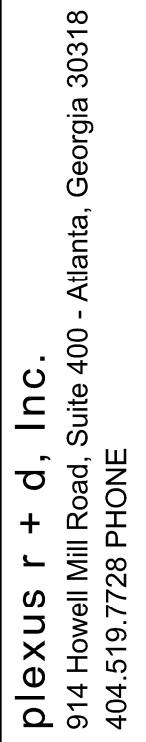

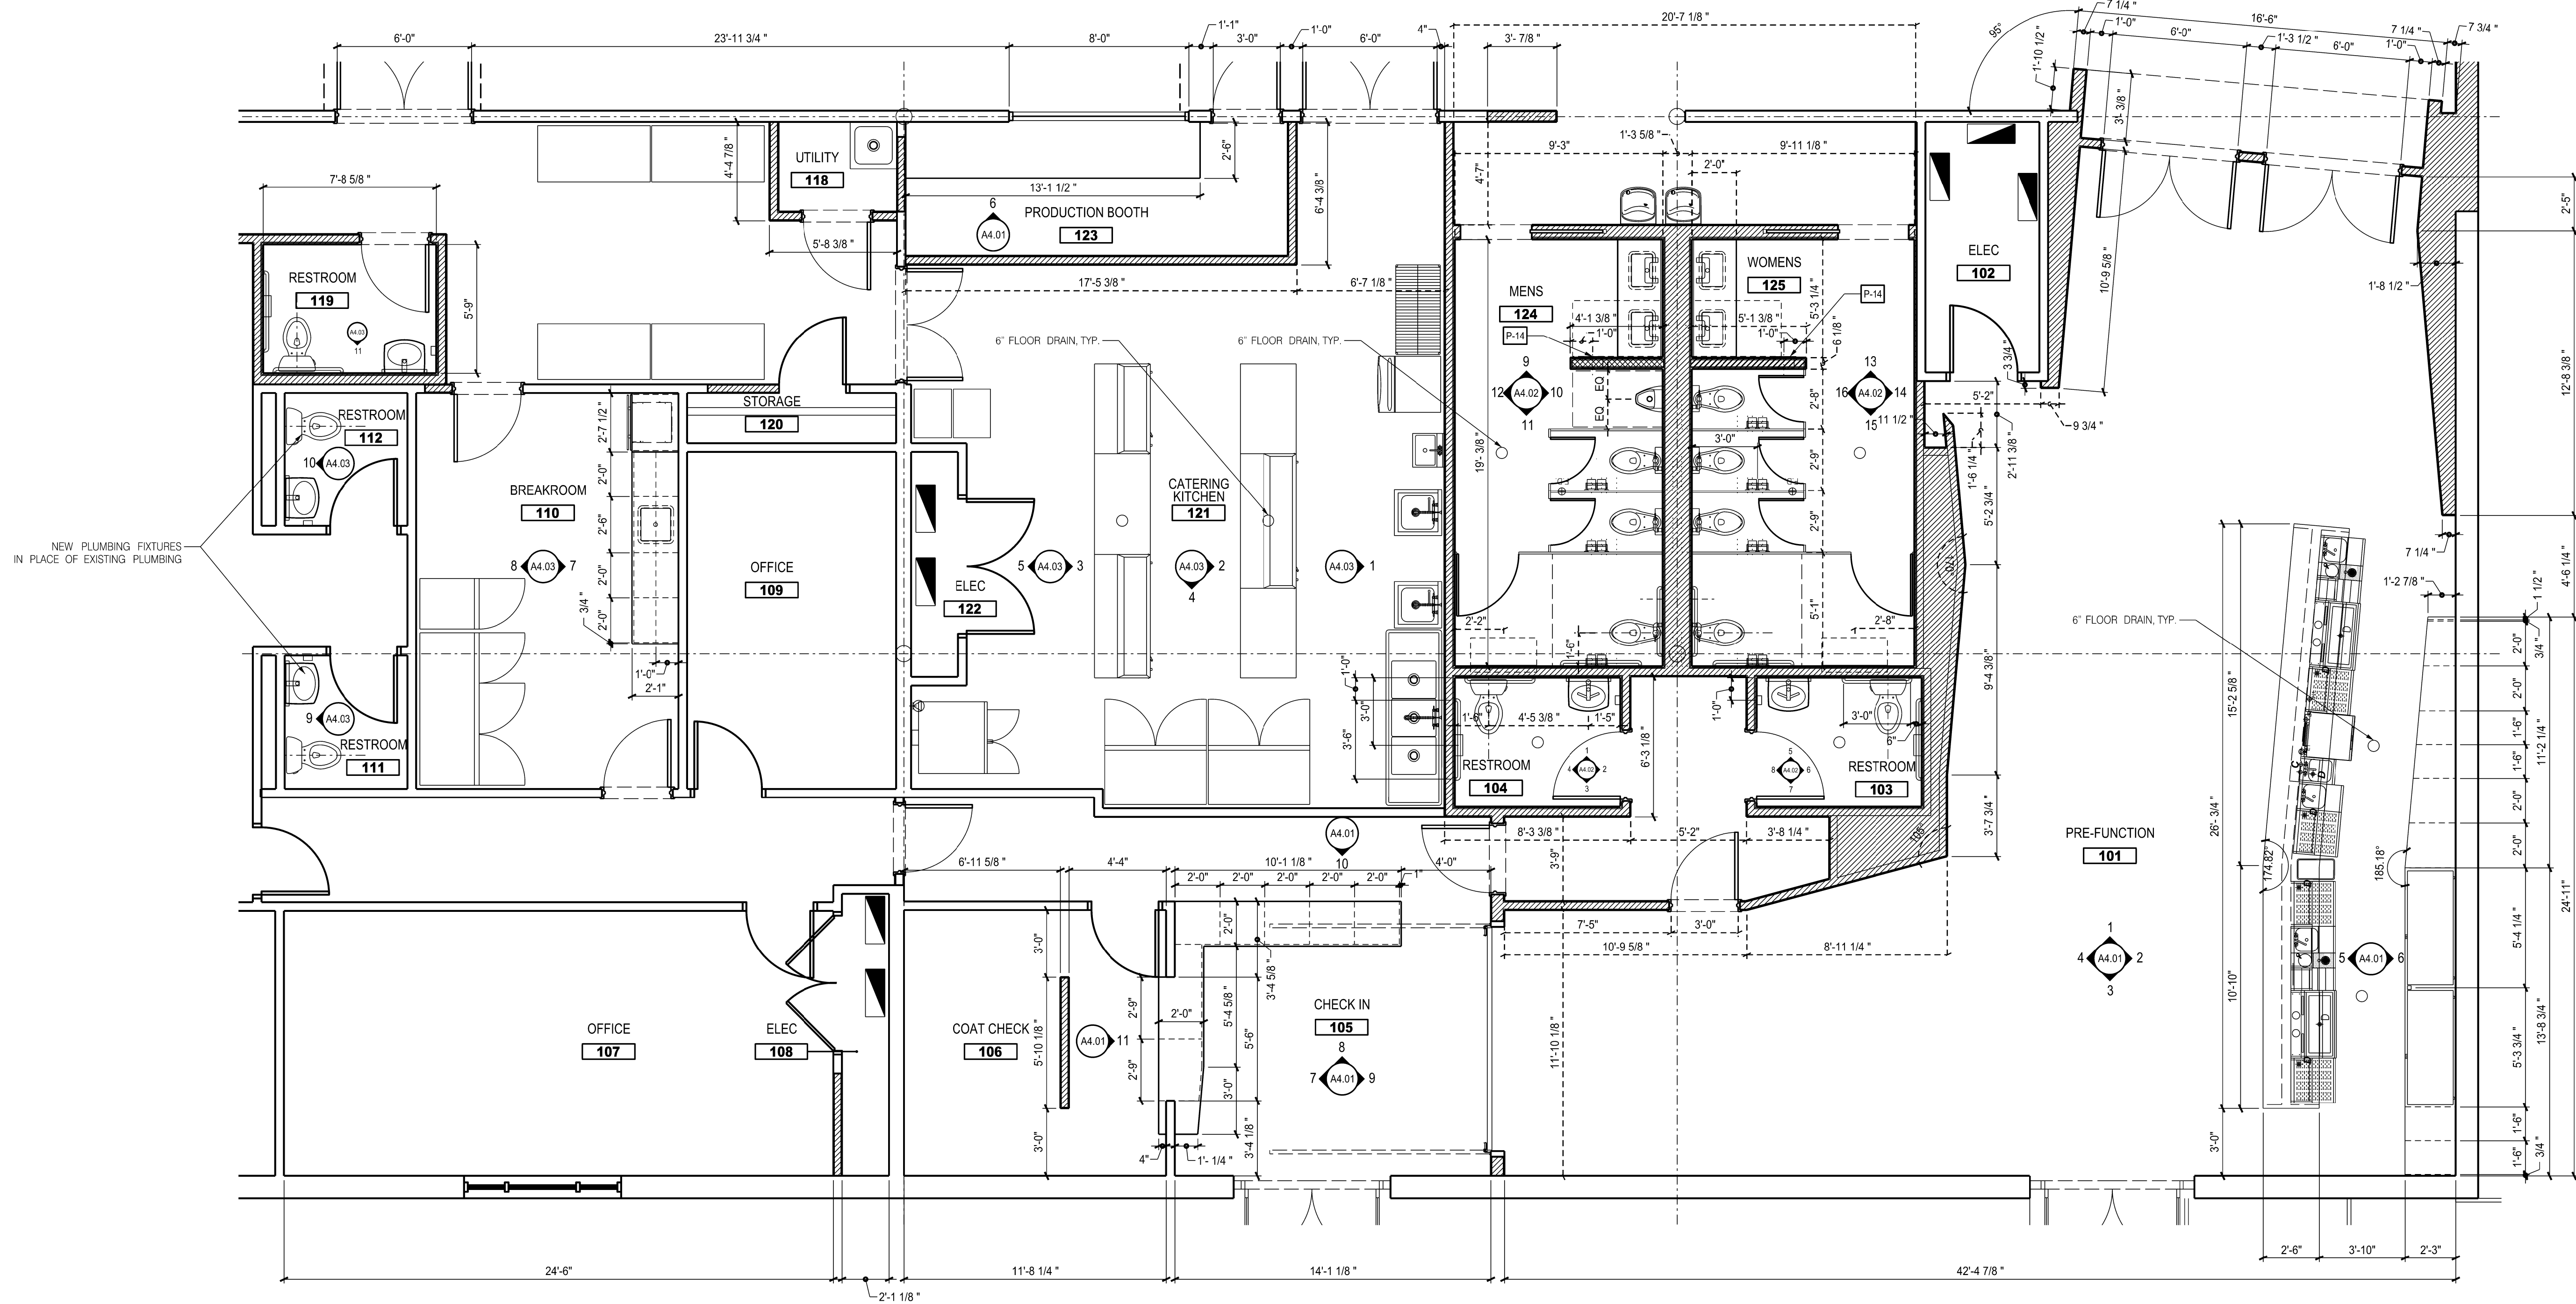

1 ENLARGED PLAN
A1.03 SCALE: 1/4" = 1'-0"

APPLIANCE SPECIFICATIONS				
TAG	DESCRIPTION/LOCATION	MANUFACTURER/VENDOR	INFORMATION	FINISH/COLOR
A1.1	DOUBLE OVEN BREAKROOM	WHIRLPOOL	WDC6EC0WS 30" DOUBLE ELECTRIC OVEN	STAINLESS STEEL
A1.2	MICROWAVE BREAKROOM	WHIRLPOOL	WMC5062ZH2 24" COUNTERTOP MICROWAVE	STAINLESS STEEL
A1.3	REFRIGERATOR BREAKROOM	WHIRLPOOL	WRS70R180M 31" FREESTANDING ALL REFRIGERATOR	STAINLESS STEEL
A1.4	3 DOOR FREEZER BREAKROOM	-	-	-

PLUMBING FIXTURE SPECIFICATIONS					
GENERAL NOTES					
IN WALL BLOCKING AT ALL WALL MOUNTED FIXTURE LOCATIONS					
FIXTURE HEIGHTS PROVIDED IN THE NOTES BELOW					
TAG	DESCRIPTION/LOCATION	MANUFACTURER/VENDOR	INFORMATION	FINISH/COLOR	NOTES/TYPICAL HEIGHTS
A1.1	UNDERMOUNT SINK BREAKROOM	KOHLER	K-3822-3-NA VAULT 25" UNDERMOUNT SINK	STAINLESS STEEL	INSTALL PER MANUFACTURER'S SPECIFICATIONS
A1.2	DECK MOUNT FAUCET BREAKROOM	KOHLER	K-596-VS SIMPLICE PULL DOWN FAUCET	VIBRANT STAINLESS	INSTALL PER MANUFACTURER'S SPECIFICATIONS
A1.3	FLOOR MOUNTED ADA TOILET RESTROOM	KOHLER	K-86037-0 HIGH-CUFF ULTRA FLOOR MOUNTED TOILET WITH K-10268-SV-CP TRIPPOINT FLUSHOMETER	WHITE POLISHED CHROME	INSTALL PER MANUFACTURER'S ADA SPECIFICATIONS
A1.4	URINAL RESTROOM	KOHLER	K-5403-ET-4 DEXTER WALL MOUNT URINAL WITH K-10268-SV-CP TRIPPOINT FLUSHOMETER	WHITE POLISHED CHROME	INSTALL PER MANUFACTURER'S ADA SPECIFICATIONS UP OF ADA URINAL 17" A.F.F. UP OF STANDARD URINAL 24" A.F.F.
A1.5	WALL MOUNTED SINK RESTROOM	WS BATH	UNLIMITED 46 WALL HUNG ADA SINK 18 3/4" SQUARE SINGLE HOLE WITH LINEA 5382 TRAP AND 5391 DRAIN	WHITE	INSTALL PER MANUFACTURER'S SPECIFICATIONS PROVIDE FIRE TREATED WOOD BLOCKING IN WALL TOP OF COUNTER 34" A.F.F.
A1.6	UNDERMOUNT SINK RESTROOM	KOHLER	K-20000-0 CAXTON RECTANGLE UNDERMOUNT SINK WITH 5391 DRAIN	-	INSTALL PER MANUFACTURER'S SPECIFICATIONS PROVIDE FIRE TREATED WOOD BLOCKING IN WALL TOP OF COUNTER 34" A.F.F.
A1.7	FAUCET RESTROOM	DYSON	AIRBLADE WASH AND DRY SHORT HAND DRYER	-	INSTALL PER MANUFACTURER'S SPECIFICATIONS TO BE PROVIDED BY OWNER
A1.8	FAUCET RESTROOM	BRADLEY	ALL IN ONE TOUCH FREE WASHBAR	POLISHED CHROME	INSTALL PER MANUFACTURER'S SPECIFICATIONS
A1.9	SOAP DISPENSER	BOBRICK	B-2013 AUTOMATIC WALL MOUNTED FOAM SOAP DISPENSER	STAINLESS STEEL	INSTALL PER MANUFACTURER'S SPECIFICATIONS CENTER OF DISPENSER 48" A.F.F.
A1.10	IPAD MIRROR	-	-	-	IPAD TO BE PROVIDED BY OWNER
A1.11	ADA MIRROR	BOBRICK	B-165 24" X 36" CHANNEL FRAME MIRROR	STAINLESS STEEL	TO BE HUNG ON TOP OF TILE BOTTOM OF MIRROR 40" A.F.F.
A1.12	GRAB BARS	BOBRICK	ADA GRAB BARS - 1 1/4" DIAMETER S.S. B-5806 36" BEHIND TOILET AND B-5806 42" BESIDE TOILET	STAINLESS STEEL	INSTALL PER MANUFACTURER'S SPECIFICATIONS PROVIDE FIRE TREATED WOOD BLOCKING IN WALL CENTER OF GRAB BAR 36" A.F.F.
A1.13	TOILET PAPER DISPENSER	BOBRICK	B-2840 TOILET TISSUE DISPENSER WITH UTILITY SHAFT	STAINLESS STEEL	INSTALL PER MANUFACTURER'S SPECIFICATIONS CENTER OF DISPENSER 47" A.F.F.
A1.14	PAPER TOWEL DISPENSER/WASTE RECEPTACLE	BOBRICK	B-3803 RECESSED PAPER TOWEL DISPENSER/WASTE RECEPTACLE	STAINLESS STEEL	INSTALL PER MANUFACTURER'S SPECIFICATIONS BOTTOM OF PAPER TOWEL DISPENSER 48" A.F.F.
A1.15	CHANGING STATION	KOALA KARE	KB10-SSRE HORIZONTAL STAINLESS STEEL RECESSED CHANGING STATION	STAINLESS STEEL	INSTALL PER MANUFACTURER'S SPECIFICATIONS TOP OF CHANGING STATION 48" A.F.F.
A1.16	HOOK	BOBRICK	B-233 CLOTHES HOOK	STAINLESS STEEL	INSTALL PER MANUFACTURER'S SPECIFICATIONS CENTER OF HOOK 48" A.F.F.
A1.17	FAUCET EMPLOYEE RESTROOM	KOHLER	K-13468-CP GEOMETRIC TOUCHLESS FAUCET	POLISHED CHROME	INSTALL PER MANUFACTURER'S SPECIFICATIONS

A1.03
ENLARGED PLAN
1/4" = 1'-0"

ISSUED
01/24/22 PRELIMINARY
XX XXXX PERMIT SET

ONE STOP PRODUCTIONS

1333 Logan Circle NW
Atlanta, GA 30318

Project Number: 777.00

ISSUED FOR
PERMIT & CONSTRUCTION

Selig Enterprises

6595 ROSWELL ROAD, SUITE G
ATLANTA, GA 30328

CONTRACTOR


STRUCTURAL

Kelly Allbright
PEC Structural Engineering
2752 East Ponce de Leon Ave
Suite D
Atlanta, Georgia 30030
404.660.6022


M.E.P. & F.P.

Westside Engineering
5525 Intestate North Parkway
Suite 200
Atlanta, GA 30328
Phone: 404-242-6240

CIVIL

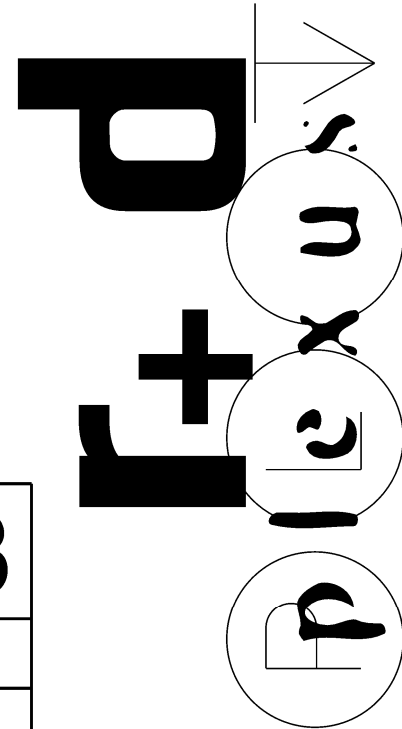

plexus r + d, Inc.
914 Howell Mill Road, Suite 400 - Atlanta, Georgia 30318
404.519.7728 PHONE
© COPYRIGHT 2022 - PLEXUS R + D, INC.

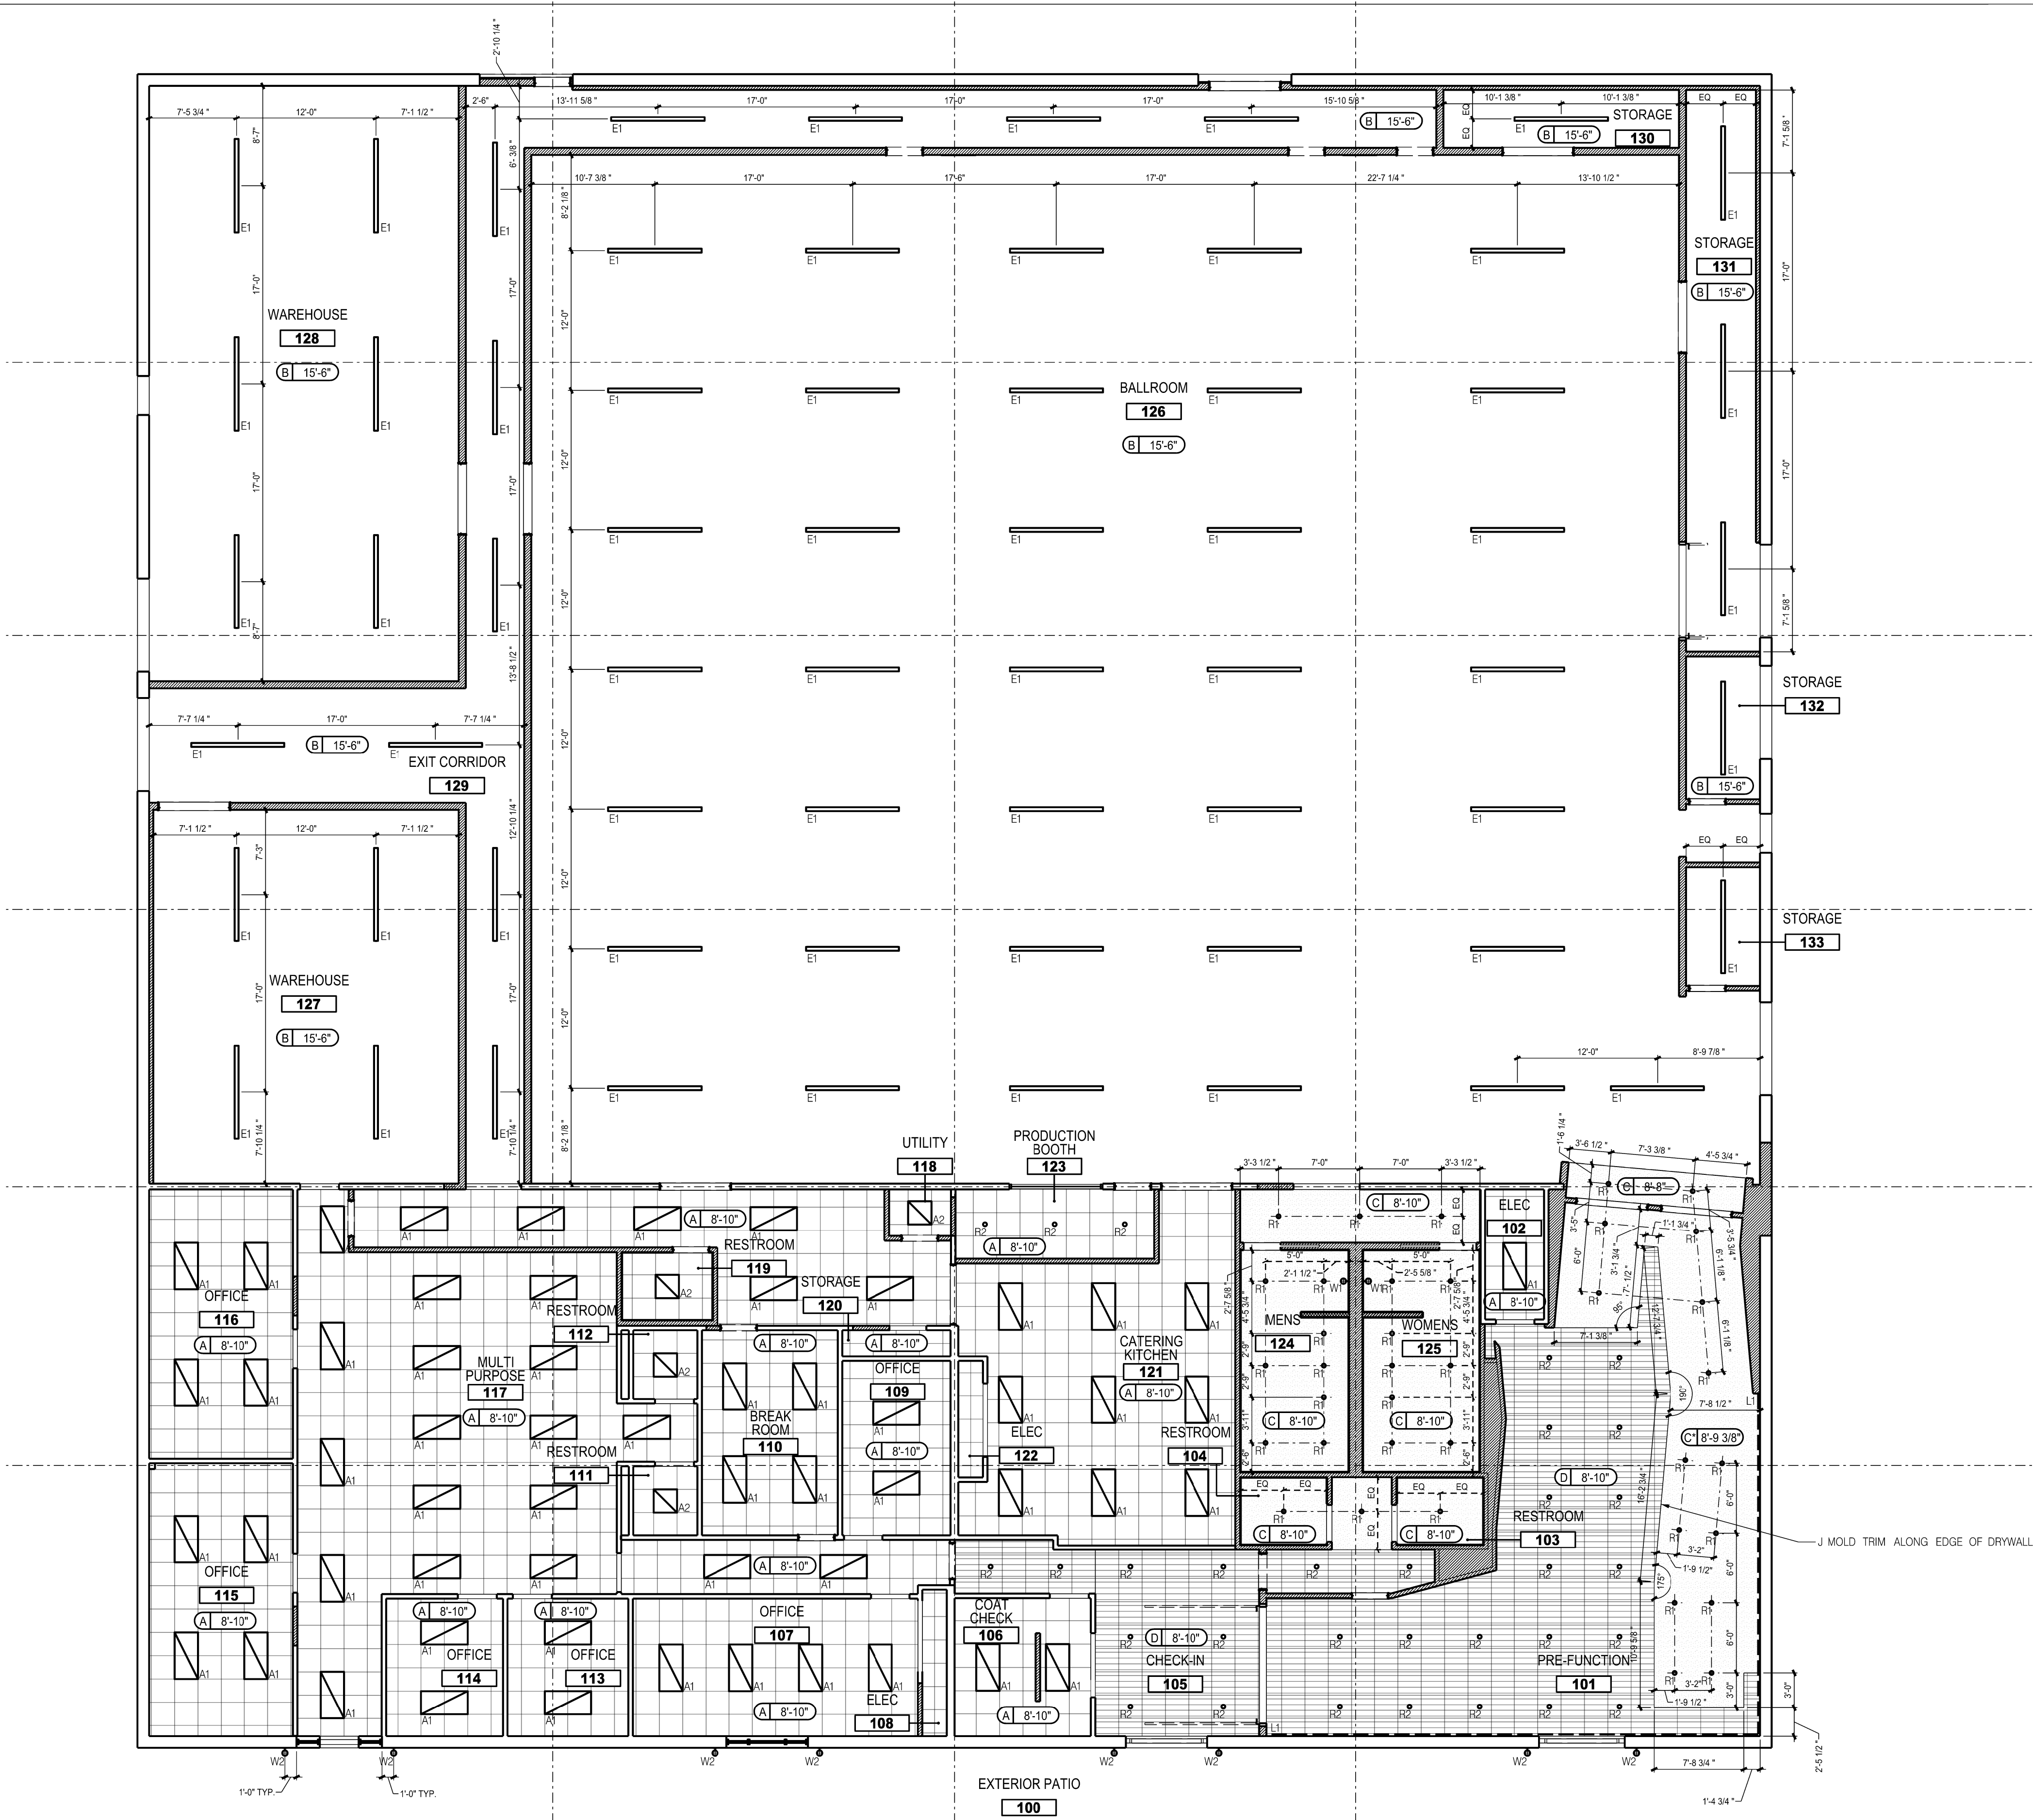

1 REFLECTED CEILING PLAN
A1.04 SCALE: 1/8" = 1'-0"

1
A2.01

GENERAL NOTES

GENERAL NOTES ARE TYPICAL AND APPLY TO ALL ASPECTS OF THE WORK.

- ALL DIMENSIONS ARE FROM FACE OF FINISHED WALL U.O.N.
- WHERE MULTIPLE SWITCHES OCCUR (SWITCHES, DIMMERS, OR BOTH), GANG GROUPS OF SWITCHES IN SAME BOX WITH A SINGLE COVER PLATE.
- ALL SWITCH COVERPLATES, (LIGHTING, DIMMERS, EXHAUST FANS, ETC.) SHALL BE MOUNTED STRAIGHT & ALIGNED
- ALL THERMOSTAT LOCATIONS TO BE APPROVED BY ARCHITECT PRIOR TO INSTALLATION
- ALL SWITCHES, DIMMERS, FAN CONTROLS AND THERMOSTATS TO BE LOCATED 48" A.F.F. TO CENTER LINE OF DEVICE U.O.N.
- CONTRACTOR TO MAINTAIN PLASTIC COVERS OVER FIXTURES DURING CONSTRUCTION TO AVOID ACCUMULATION OF DIRT AND FINGERPRINTS ON LENS SURFACE.
- ALL ELECTRICAL ITEMS ARE SHOWN FOR REFERENCE ONLY. COORDINATE ALL ELECTRICAL ITEMS WITH ELECTRICAL DRAWINGS.
- COORDINATE LOCATION OF ALL EGRESS, EMERGENCY, & TEMPORARY LIGHTING WITH ELECTRICAL.
- FINISHED CEILING HEIGHTS INDICATED ARE FROM FINISHED FLOOR.
- AT EXISTING ACT CEILINGS TO REMAIN, CONTRACTOR SHALL REPLACE MISSING, DAMAGED, OR STAINED ACT TILES TO MATCH EXISTING.
- ALL LIGHT FIXTURES TO BE DIMMABLE - SEE ELECTRICAL
- ALL NEW AND EXISTING CEILINGS THAT ARE NOT ALREADY PAINTED WITH EPOXY PAINT SHALL BE PAINTED WITH EPOXY PAINT.
- ALL CEILING AND FIXTURE HEIGHTS SHALL BE MEASURED FROM FINISH FLOOR. (NOTE: EXISTING PRE-ENGINEERED STRUCTURAL MEMBERS SLOPE TO DOWNSPOUT SIDE OF THE BUILDING)

CEILING TYPES

TYPE	SYMBOL	DESCRIPTION
A		EXISTING GRID TO BE PAINTED TO MATCH NEW 2' X 2' ARMSTRONG ACOUSTICAL CEILING TILE
B		OPEN TO STRUCTURE, TO BE PAINTED, (SEE FINISH SCHEDULE) PROVIDE MINIMUM R21 INSULATION FOR A TOTAL ASSEMBLY OF R30. ATTACH TO UNDERSIDE OF EXISTING METAL DECK. PRICE ALTERNATE 1: 3.5" POLYISO INSULATION BOARD PRICE ALTERNATE 2: PAPER BATT INSULATION
C		5/8" GYPSUM BOARD, TO BE PAINTED, (SEE FINISH SCHEDULE) * G.W.B. TO BE ATTACHED TO EXISTING CEILING GRID
D		ATTACH PERFORATED CORRUGATED METAL PANEL TO EXISTING GRID AND ACT THAT IS PAINTED BLACK

SYMBOLS LEGEND

	MFR: - TYPE: EXISTING 2' X 4' TROFFERS MODEL: - NOTES: REPAIR AND REPLACE AS NEEDED. RELOCATE AS NEEDED.
	MFR: - TYPE: 2' X 2' INDIRECT TROFFER MODEL: - NOTES: SEE ELECTRICAL FOR SPECIFICATION
	MFR: - TYPE: EXISTING LINEAR PENDANTS MODEL: - NOTES: VERIFY FIXTURE CAN BE DIMMABLE AND RELOCATE AS NECESSARY
	MFR: - TYPE: 4' LED WALL MODEL: - NOTES: PROVIDED BY OWNER
	MFR: - TYPE: 4" RECESSED CAN LIGHT MODEL: - NOTES: SEE ELECTRICAL FOR SPECIFICATION
	MFR: - TYPE: 4" RECESSED CAN LIGHT IN ACT MODEL: - NOTES: SEE ELECTRICAL FOR SPECIFICATION
	MFR: SONNETMAN TYPE: DECORATIVE SCONCE MODEL: 60" STIX PLUS LED BATHROOM WALL BAR NOTES: -
	MFR: SONNETMAN TYPE: OUTDOOR DECORATIVE SCONCE MODEL: 24" SWORD OUTDOOR LED WALL SCONCE NOTES: -
	MFR: - TYPE: EXIT SIGN MODEL: SEE ELECTRICAL DRAWINGS FOR SPECIFICATIONS NOTES: -

A1.04

REFLECTED CEILING PLAN
1/8" = 1'-0"

ISSUED
01/24/22 PRELIMINARY
XX XXXX PERMIT SET

ONE STOP PRODUCTIONS

1333 Logan Circle NW
Atlanta, GA 30318

Selig Enterprises
6595 ROSWELL ROAD, SUITE G
ATLANTA, GA 30328

Project Number: 777.00
ISSUED FOR
PERMIT & CONSTRUCTION

CONTRACTOR


STRUCTURAL

Kelly Allbright
PEC Structural Engineering
2752 East Ponce de Leon Ave
Suite D
Atlanta, Georgia 30030
404.660.6022


M.E.P. & F.P.

Westside Engineering
5525 Interstate North Parkway
Suite 200
Atlanta, GA 30328
Phone: 404-242-6240

CIVIL

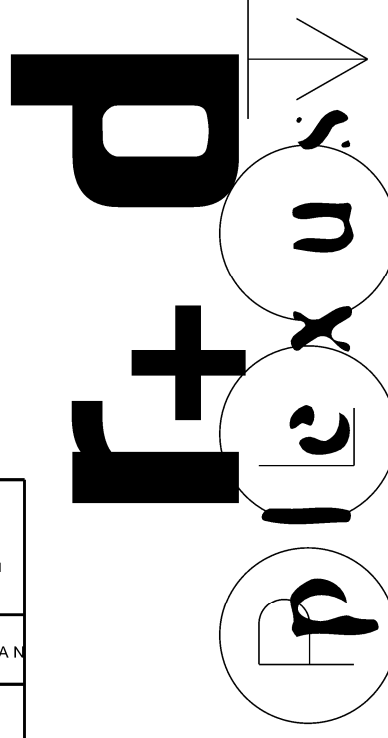

plexus r + d, Inc.
914 Howell Mill Road, Suite 400 - Atlanta, Georgia 30318
404.519.7728 PHONE
© COPYRIGHT 2022 - PLEXUS R + D, INC.

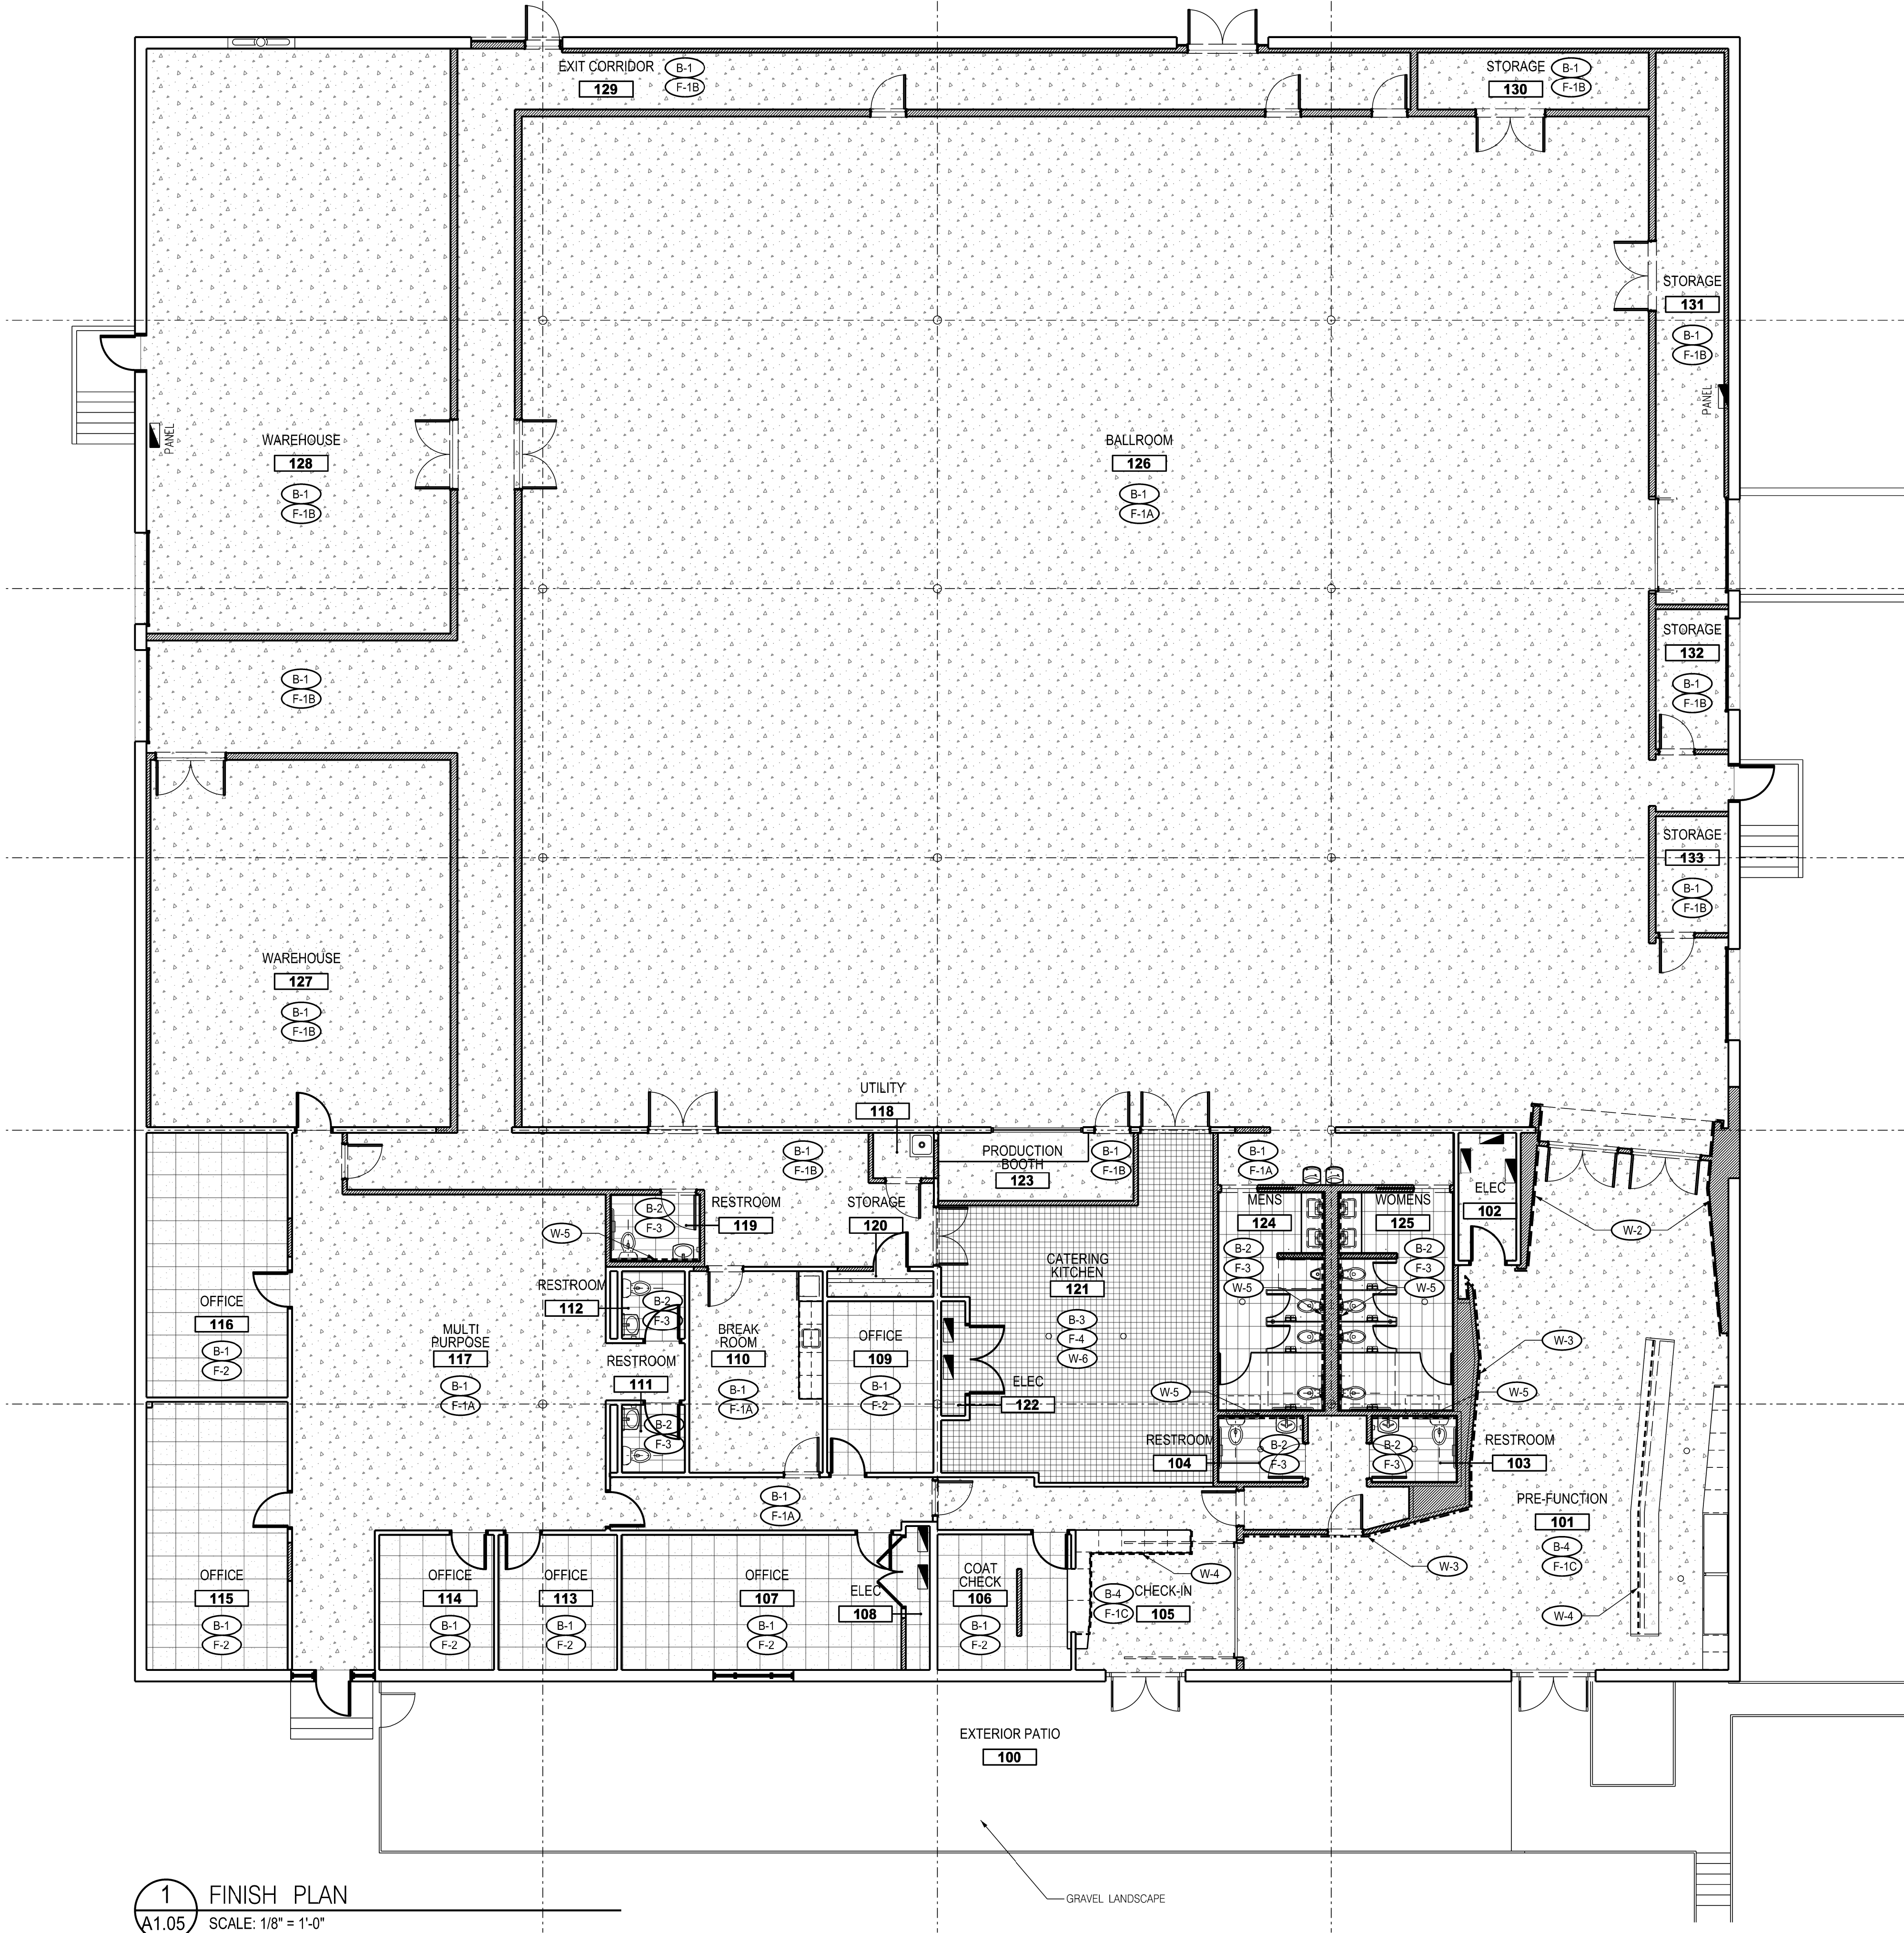

1 FINISH PLAN
A1.05 SCALE: 1/8" = 1'-0"

FINISH LEGEND					
TAG	DESCRIPTION/LOCATION	MANUFACTURER/VENDOR	INFORMATION	FINISH/COLOR	CONTACT/NOTES
B-1	BASE - RUBBER GENERAL L.V.O.	ROPPE	6" COVE BASE	100 BLACK	MOHELE MUSGROVE 404.660.0241 MMUSGROVE@GMAIL.COM
B-2	BASE - TILE RESTROOMS	TRINITY TILE	6"x12" TILE COVE BASE GROUT: CUSTOM 540 TRUFFLE	BALANCE GRAY	JAKE ADAMS 678.896.9845 JADAMS@TRINITYSURFACES.COM
B-3	BASE - QUARRY TILE KITCHEN	METROPOLITAN CERAMICS	QUARRY BASICS 6" X 6" COVE BASE GROUT: CUSTOM 541 WALNUT	PURITAN GRAY	JAKE ADAMS 678.896.9845 JADAMS@TRINITYSURFACES.COM
B-4	BASE - WOOD BASE PREFUNCTION	CONTRACTOR PROVIDE	1X6 WOOD BASEBOARD	PAINTED PT-3	-
CT-1	COUNTERTOP - PLEXI PREFUNCTION	-	-	-	-
CT-2	COUNTERTOP - PLEXI CHECKIN	-	-	-	-
CT-3	COUNTERTOP - QUARTZ RESTROOM	CAESARSTONE	QUARTZ SURFACES 3CM THICKNESS	1141 PURE WHITE	DAVID HENNINGTON DAVID.HENNINGTON@CAESARSTONEUS.COM
CT-4	COUNTERTOP - QUARTZ BREAKROOM/BEHIND BAR	CAESARSTONE	QUARTZ SURFACES 3CM THICKNESS	4120 RAVEN	DAVID HENNINGTON DAVID.HENNINGTON@CAESARSTONEUS.COM
CT-5	COUNTERTOP - LAMINATE PRODUCTION BOOTH	FORMICA	LAMINATE SHEET	6414-NG BLACK RIFTWOOD	LESLIE GALFANAKIS LESLIE.GALFANAKIS@FORMICA.COM
F-1A	FLOORING - CONCRETE GENERAL	CONTRACTOR PROVIDE	EXISTING CONCRETE TO BE PATCHED AND REPAIRED AS NEEDED CLEAN POLISH AND SEAL CONCRETE	APPLY GLOSSY POLISH	-
F-1B	FLOORING - CONCRETE BACK OF HOUSE	CONTRACTOR PROVIDE	EXISTING CONCRETE TO BE PATCHED AND REPAIRED AS NEEDED CLEAN POLISH AND SEAL CONCRETE	-	-
F-1C	FLOORING - CONCRETE PREFUNCTION	CONTRACTOR PROVIDE	EXISTING CONCRETE TO BE PATCHED AND REPAIRED AS NEEDED CLEAN POLISH AND SEAL CONCRETE	APPLY BLACK GLOSSY POLISH	-
F-2	FLOORING - CARPET OFFICES	SHAW CONTRACT	24" X 24" SIMPLY BY NATURE OFFSET TILE DIRECT GULE	SHINY PEBBLE	JESSA FINNEGAN 404.558.1806 JESSA.FINNEGAN@SHAWCONTRACT.COM
F-3	FLOORING - TILE RESTROOM	TRINITY TILE	12" X 24" SOCIAL TILE GROUT: CUSTOM 540 TRUFFLE	BALANCE GRAY	JAKE ADAMS 678.896.9845 JADAMS@TRINITYSURFACES.COM
F-4	FLOORING - QUARRY TILE KITCHEN	METROPOLITAN CERAMICS	QUARRY BASICS 6" X 6" GROUT: CUSTOM 541 WALNUT	PURITAN GRAY	-
FT-1	FINISH TRANSITION CONCRETE TO LVTILE	SCHULTER	RENO-11	SATIN ANODIZED ALUM	INSTALLER TO VERIFY TRANSITION WITH MATERIAL THICKNESS
FT-2	FINISH TRANSITION LVT TO TILE	SCHULTER	SCHE-1	SATIN ANODIZED ALUM	INSTALLER TO VERIFY TRANSITION WITH MATERIAL THICKNESS
HW	HARDWARE CABINET PULLS	RICHELIEU	BP90802870 FINGER CABINET PULL	STAINLESS STEEL	-
MW-1	MILLWORK BACK OF BAR	FORMICA	LAMINATE SHEET	839-BH STAINLESS BRUSH FINISH	LESLIE GALFANAKIS LESLIE.GALFANAKIS@FORMICA.COM
MW-2	MILLWORK CHECKIN	FORMICA	LAMINATE SHEET	6414-NG BLACK RIFTWOOD	LESLIE GALFANAKIS LESLIE.GALFANAKIS@FORMICA.COM
MW-3	MILLWORK RESTROOM	FORMICA	LAMINATE SHEET	839-BH STAINLESS BRUSH FINISH	LESLIE GALFANAKIS LESLIE.GALFANAKIS@FORMICA.COM
MW-4	MILLWORK BREAKROOM	FORMICA	LAMINATE SHEET	6414-NG BLACK RIFTWOOD	LESLIE GALFANAKIS LESLIE.GALFANAKIS@FORMICA.COM
PT-1	PAINT GENERAL WALLS	SHERWIN WILLIAMS	PRIMER: PROMAR200 ZERO-VOC LATEX PRIMER 828W6000 COAT1A2: PROMAR200 ZERO-VOC INTERIOR LATEX 830-2000	COLOR: 7022 KNITTING NEEDLES FINISH: EGGSHELL	-
PT-2	PAINT GENERAL OPEN CEILING	SHERWIN WILLIAMS	PRIMER: PROMAR200 ZERO-VOC LATEX PRIMER 828W6000 COAT1A2: PROMAR200 ZERO-VOC INTERIOR LATEX 830-2000	COLOR: SW7004 SNOWBOUND FINISH: EGGSHELL	-
PT-3	PAINT GENERAL TRIM AND DOOR	SHERWIN WILLIAMS	PRIMER: PREPRITE PRO-BLOCK LATEX/SEALER 858SERIES COAT1A2: PRO-INDUSTRIAL ACRIPLUX SEMI-GLOSS 866-400	COLOR: SW9172 GRAY SHINGLE FINISH: SEMI-GLOSS	-
PT-4	PAINT RESTROOM WALLS AND CEILING	SHERWIN WILLIAMS	PRIMER: PROMAR 200 ZERO-VOC LATEX PRIMER 828W6000 COAT1A2: PRO-INDUSTRIAL PRE-CATALYZED WATERBASED EPOXY SEMI-GLOSS 866-400	COLOR: 7004 SNOWBOUND FINISH: EGGSHELL	-
W-1	WALL FINISH - GYPSUM GENERAL	CONTRACTOR PROVIDE	GYPSUM WALL PAINTED	PAINT: EGGSHELL FINISH SEE PAINT SCHEDULE	-
W-2	WALL FINISH - RECLAIMED WID PREFUNCTION	STRKWOOD	RECLAIMED TEXTURED PEEL AND STICK WOOD PLANKS	GRAYSTONE	-
W-3	WALL FINISH - GRAPHIC PREFUNCTION	-	CUSTOM WALLCOVERING GRAPHIC	-	-
W-4	WALL FINISH - RECLAIMED WID BAR FRONT	STRKWOOD	RECLAIMED TEXTURED PEEL AND STICK WOOD PLANKS	GRAYSTONE	-

GENERAL

CONTRACTOR TO PROVIDE ALL FINISH SAMPLES FOR DESIGNER APPROVAL PRIOR TO ORDER, FABRICATION AND/OR INSTALLATION

1. ALL WALLS TO BE PAINTED PT-1 UNO

2. CERTAIN FINISHES SPECIFIED MAY REQUIRE UP TO 8-10 WEEKS LEADTIME. CONTRACTOR IS RESPONSIBLE FOR TIMELY PRODUCT ORDERING SCHEDULE AND ENSURING PRODUCT ARRIVES WITHIN CONSTRUCTION SCHEDULE.

3. ALL OUTLETS AND SWITCH PLATE COVERS TO MATCH WALL COLOR. STAINLESS OUTLET AND SWITCH PLATE COVERS ON TILE WALLS.

4. SEE FINISH PLAN FOR FLOORING PATTERN AND LAYOUT

LEGEND	
PT-1	FINISH TAG
■■■■	WALL FINISH LOCATIONS
□	NEW FLOORING
▨	AREAS NOT IN SCOPE
F-1	FLOORING TRANSITION
F-2	FLOORING TRANSITION
EXIST	EXISTING FINISH TAG

ISSUED
01/24/22 PRELIMINARY
XX XXXX PERMIT SET

ONE STOP PRODUCTIONS
1333 Logan Circle NW
Atlanta, GA 30318

Project Number: 777.00
ISSUED FOR PERMIT & CONSTRUCTION

Selig Enterprises
6595 ROSWELL ROAD, SUITE G
ATLANTA, GA 30328


CONTRACTOR

Kelly Albright
PEC Structural Engineering
2752 East Ponce de Leon Ave
Suite D
Atlanta, Georgia 30030
404.660.6022

STRUCTURAL


Westside Engineering
5525 Interstate North Parkway
Suite 200
Atlanta, GA 30328
Phone: 404-242-6240

CIVIL

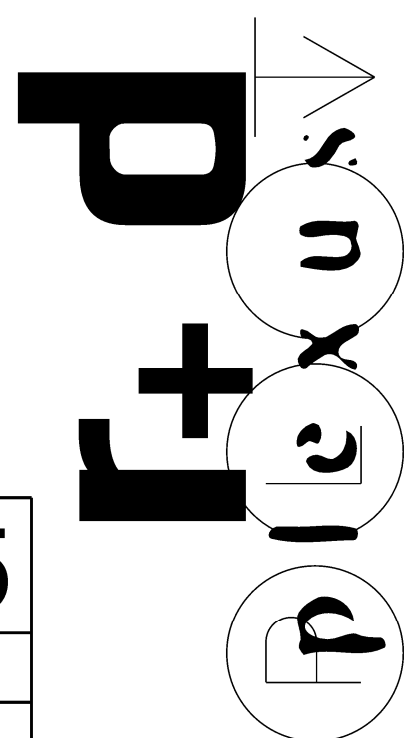

plexus r + d, Inc.
914 Howell Mill Road, Suite 400 - Atlanta, Georgia 30318
404.519.7728 PHONE
© COPYRIGHT 2022 - PLEXUS R + D, INC.


A1.05
FINISH PLAN
1/8" = 1'-0"

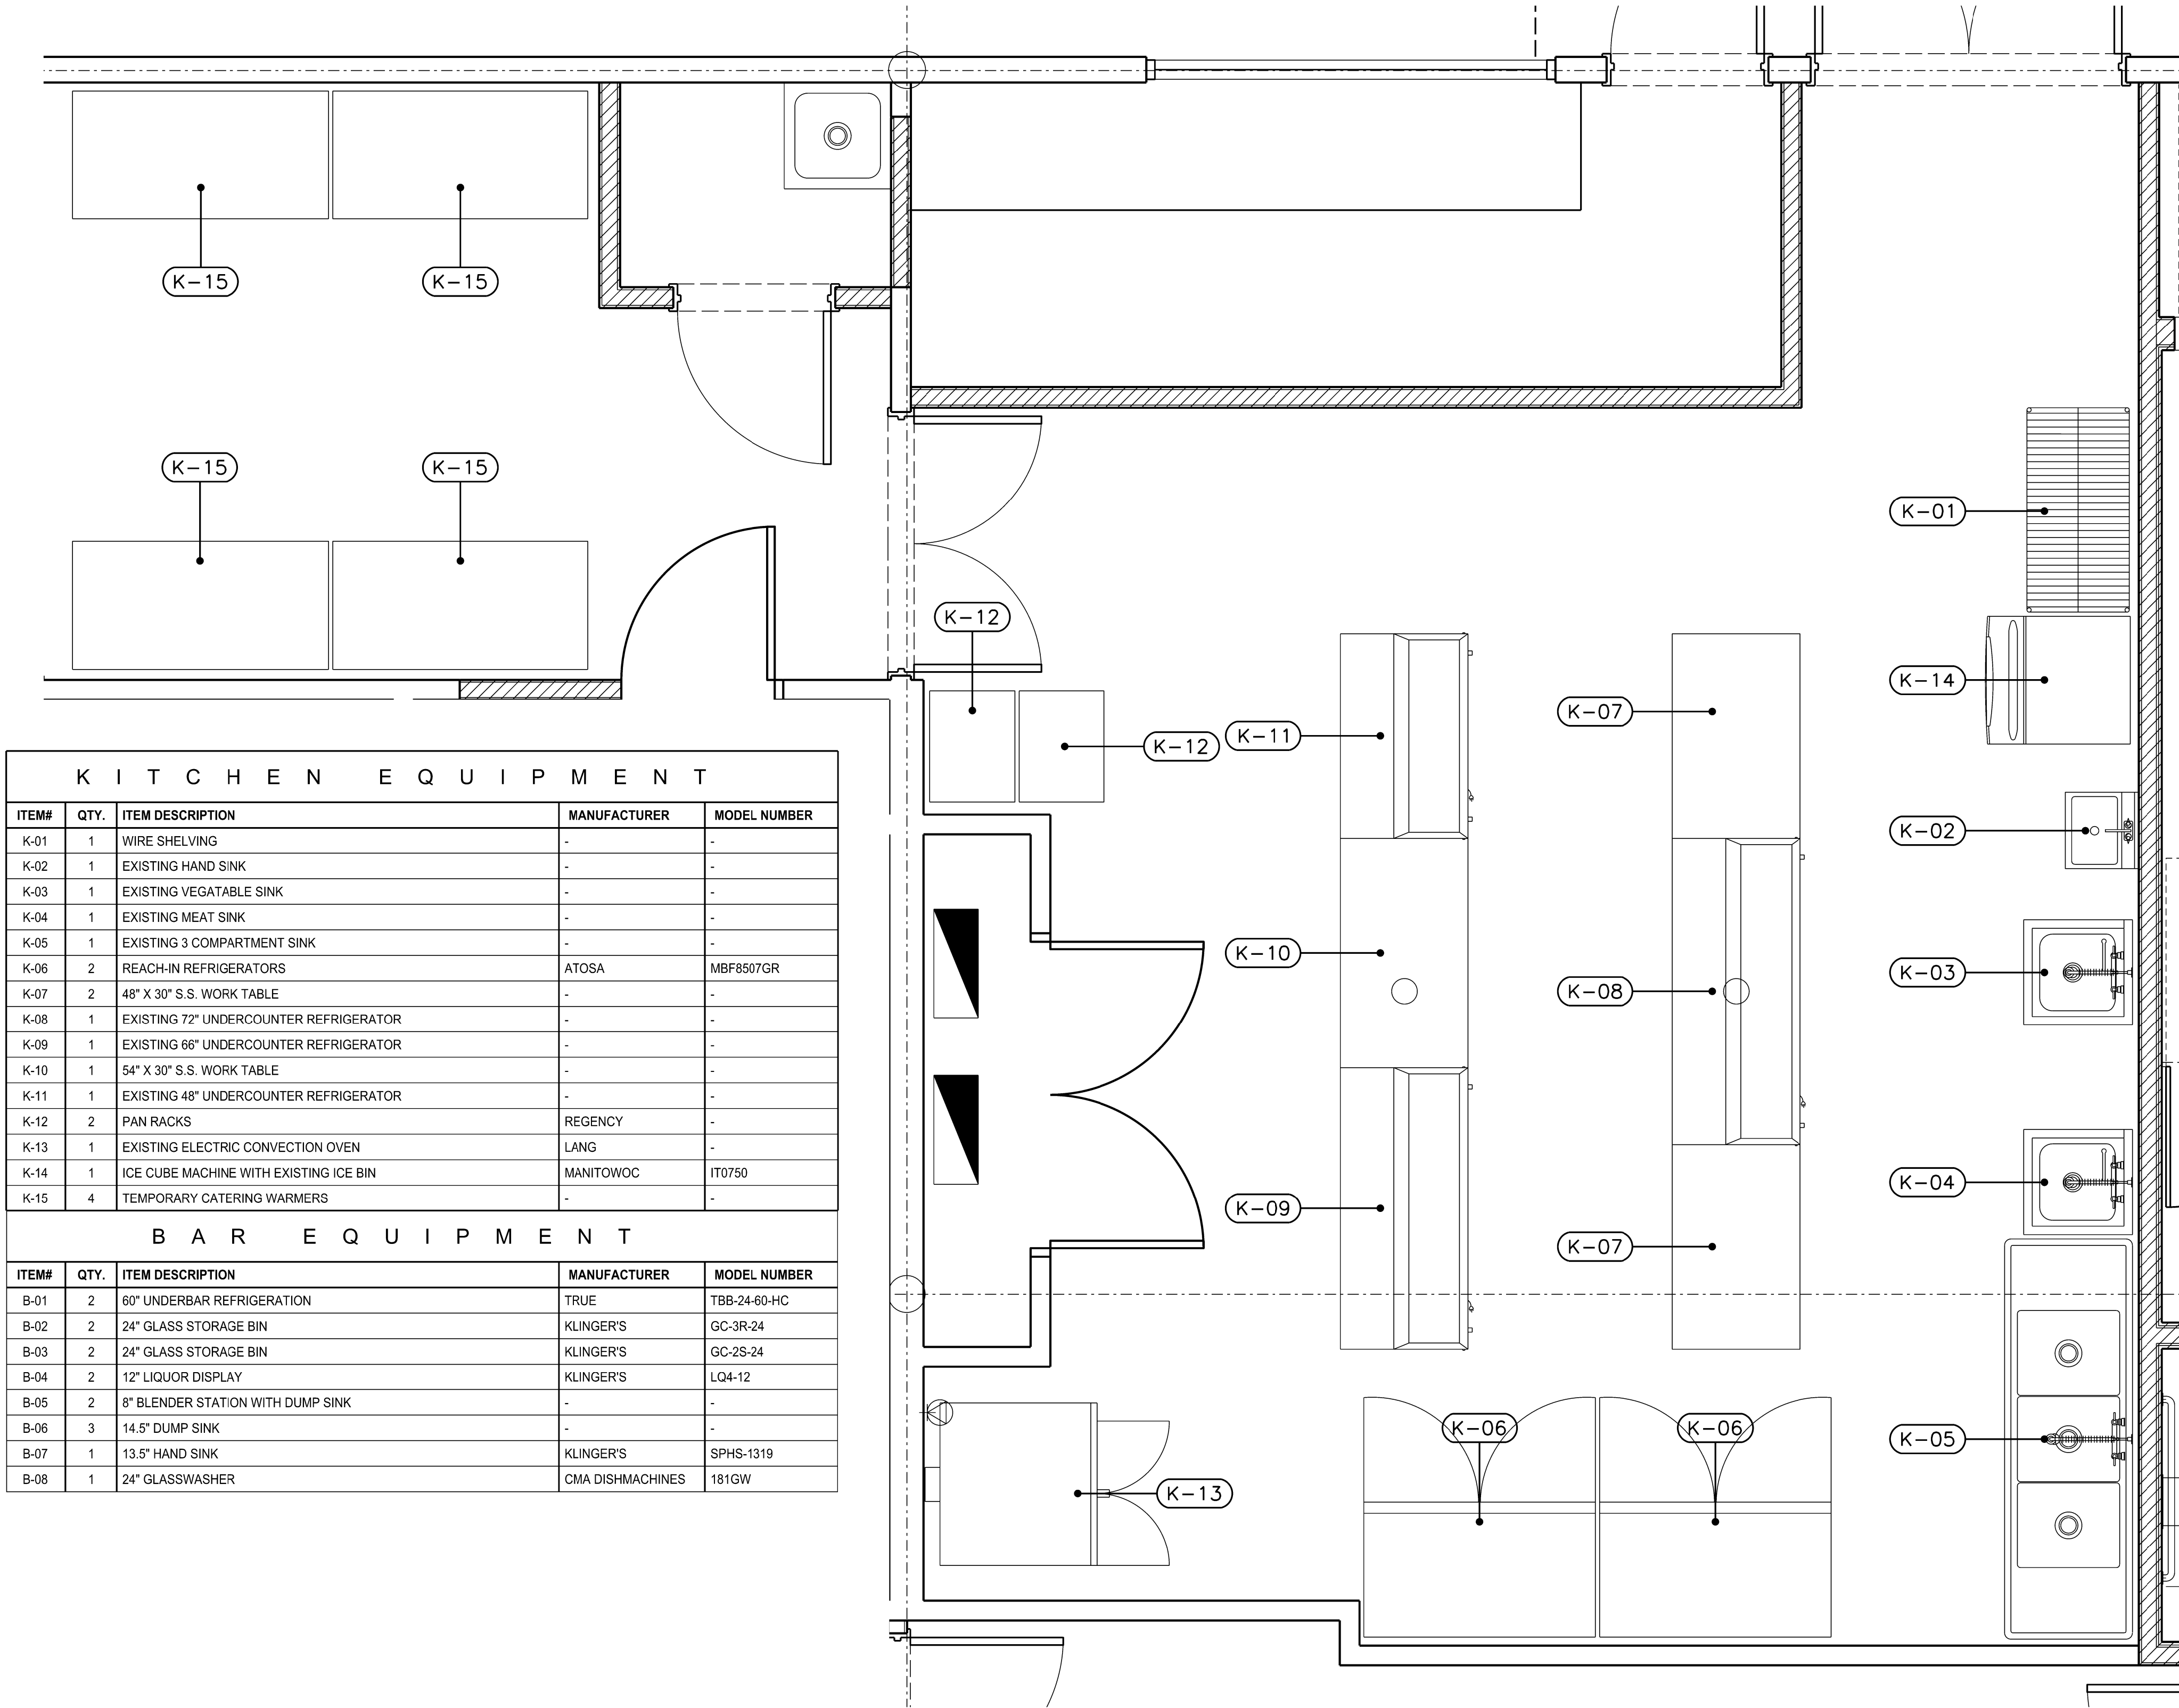

KITCHEN EQUIPMENT			
ITEM#	QTY.	ITEM DESCRIPTION	MANUFACTURER
K-01	1	WIRE SHELVING	-
K-02	1	EXISTING HAND SINK	-
K-03	1	EXISTING VEGETABLE SINK	-
K-04	1	EXISTING MEAT SINK	-
K-05	1	EXISTING 3 COMPARTMENT SINK	-
K-06	2	REACH-IN REFRIGERATORS	ATOSA
K-07	2	48" X 30" S.S. WORK TABLE	-
K-08	1	EXISTING 72" UNDERCOUNTER REFRIGERATOR	-
K-09	1	EXISTING 66" UNDERCOUNTER REFRIGERATOR	-
K-10	1	54" X 30" S.S. WORK TABLE	-
K-11	1	EXISTING 48" UNDERCOUNTER REFRIGERATOR	-
K-12	2	PAN RACKS	REGENCY
K-13	1	EXISTING ELECTRIC CONVECTION OVEN	LANG
K-14	1	ICE CUBE MACHINE WITH EXISTING ICE BIN	MANITOWOC
K-15	4	TEMPORARY CATERING WARMERS	-


BAR EQUIPMENT			
ITEM#	QTY.	ITEM DESCRIPTION	MANUFACTURER
B-01	2	60" UNDERBAR REFRIGERATION	TRUE
B-02	2	24" GLASS STORAGE BIN	KLINGER'S
B-03	2	24" GLASS STORAGE BIN	KLINGER'S
B-04	2	12" LIQUOR DISPLAY	KLINGER'S
B-05	2	8" BLENDER STATION WITH DUMP SINK	-
B-06	3	14.5" DUMP SINK	-
B-07	1	13.5" HAND SINK	KLINGER'S
B-08	1	24" GLASSWASHER	CMA DISHMACHINES

1 EQUIPMENT PLAN – CATERING KITCHEN
A1.06 SCALE: 1/2" = 1'-0"

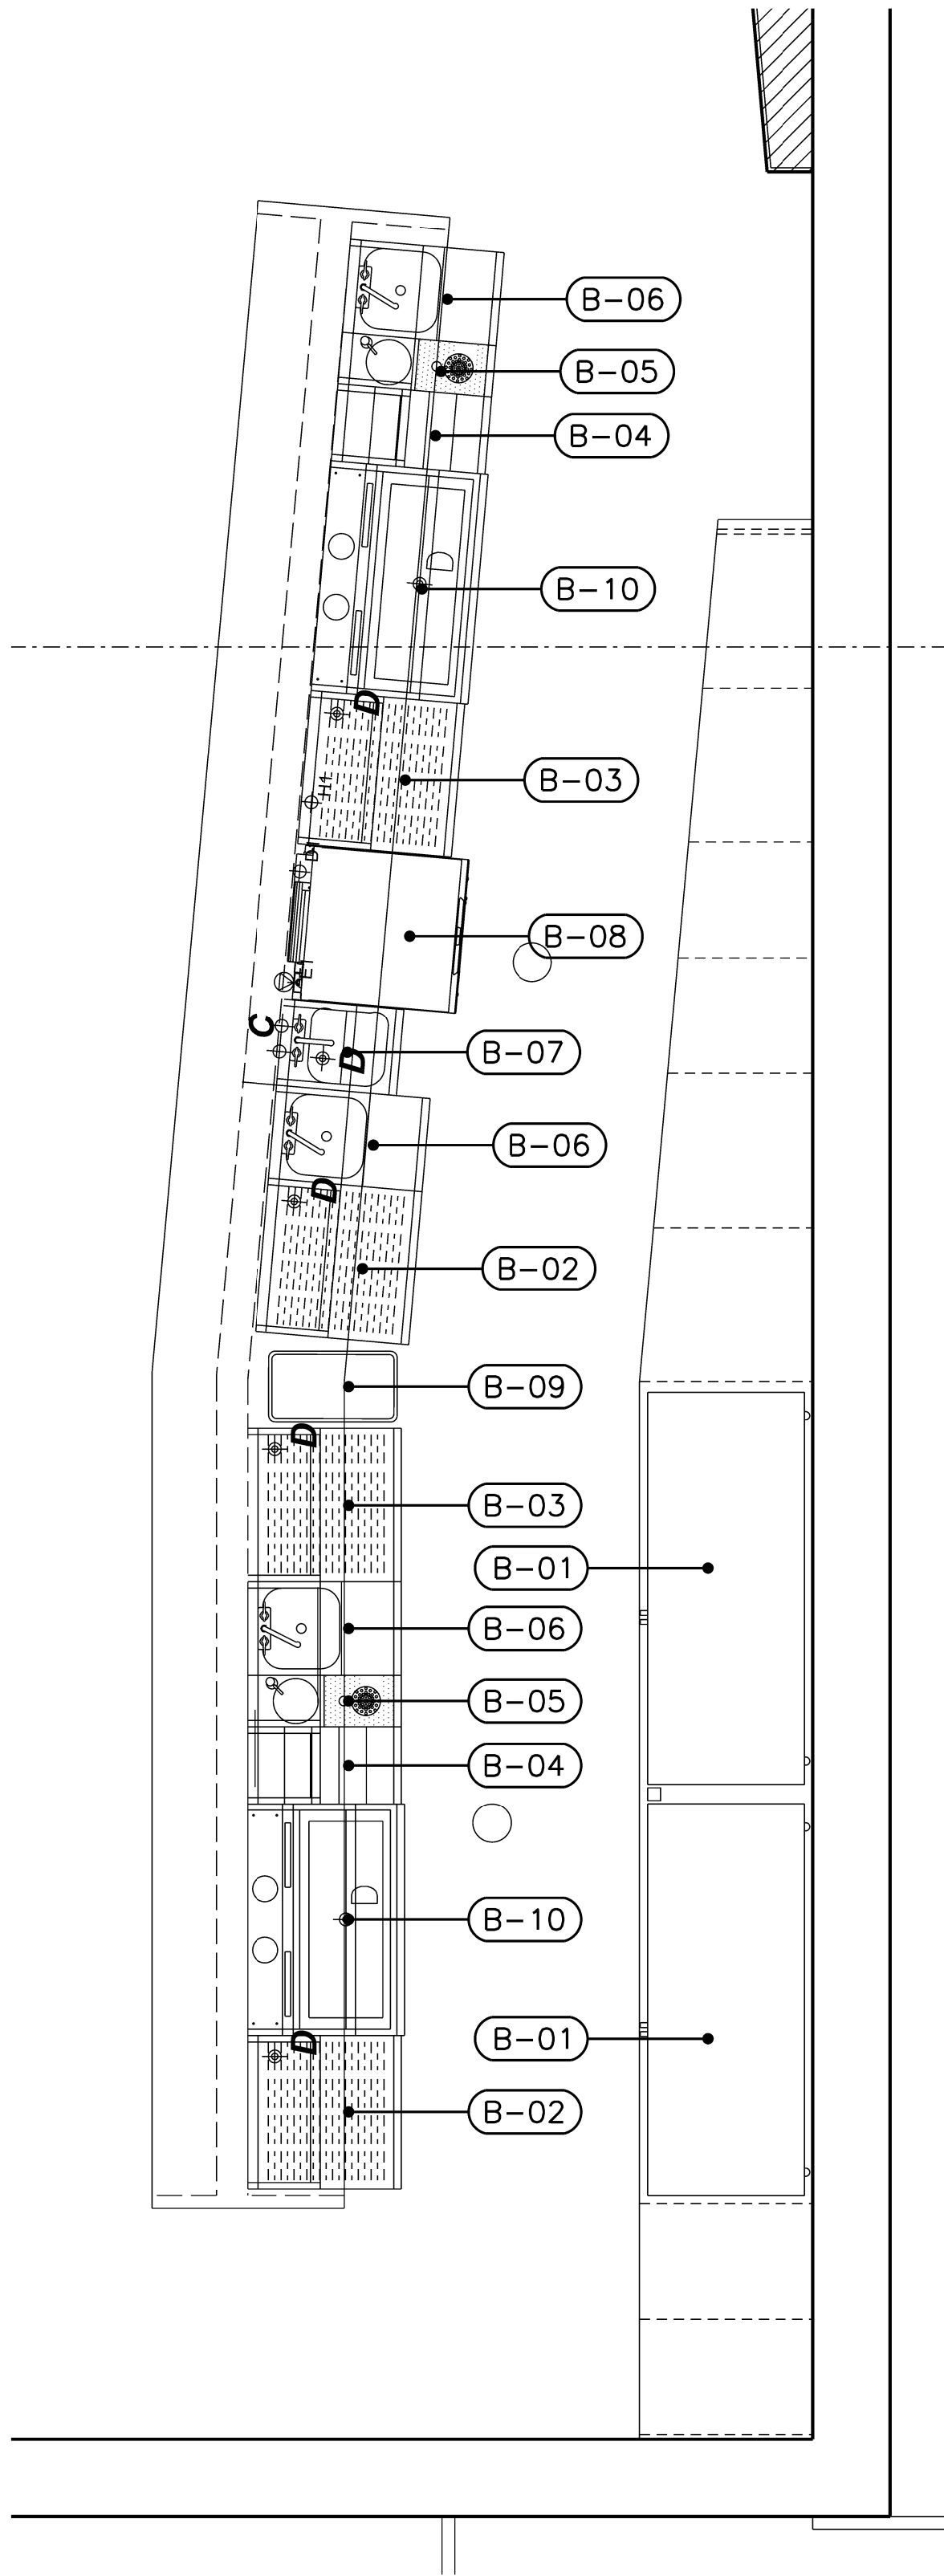

2 EQUIPMENT PLAN – PREFUNCTION BAR
A1.06 SCALE: 1/2" = 1'-0"

A1.06
EQUIPMENT PLAN
1/2" = 1'-0"

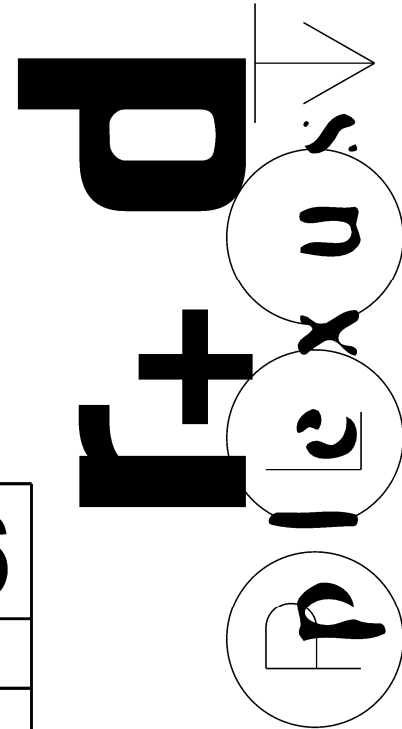

plexus r + d, inc.
914 Howell Mill Road, Suite 400 - Atlanta, Georgia 30318
404.519.7728 PHONE

© COPYRIGHT 2022 - PLEXUS R + D, INC.

ONE STOP PRODUCTIONS
1333 Logan Circle NW
Atlanta, GA 30318

Project Number: 777.00
ISSUED FOR
PERMIT & CONSTRUCTION
Selig Enterprises
6595 ROSWELL ROAD, SUITE G
ATLANTA, GA 30328

CONTRACTOR








STRUCTURAL

Kelly Albright
PEC Structural Engineering
2752 East Ponce de Leon Ave
Suite D
Atlanta, Georgia 30030
404.660.6022

M.E.P. & F.P.

Westside Engineering
5525 Intestate North Parkway
Suite 200
Atlanta, GA 30328
Phone: 404-242-6240

CIVIL

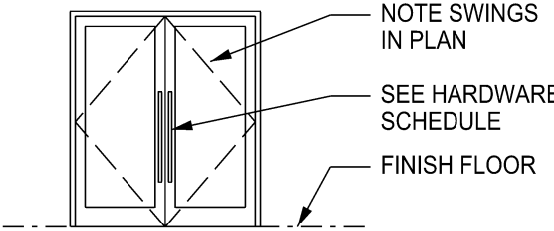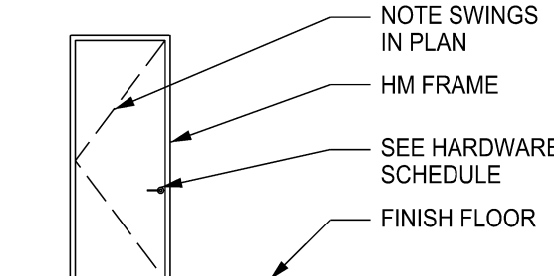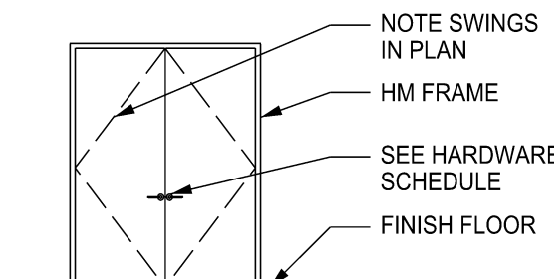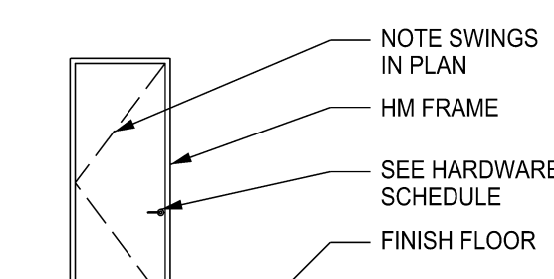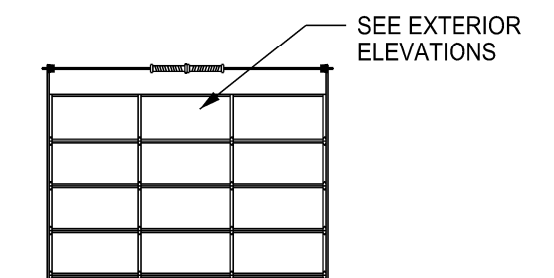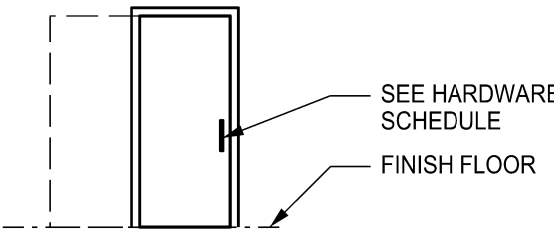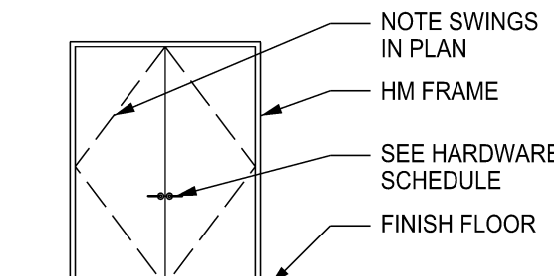D O O R T Y P E S		
TYPE	DESCRIPTION	SYMBOL
A	EXTERIOR METAL+ GLASS ENTRY DOOR SEE DOOR SCHEDULE FOR SIZE	
B	INTERIOR SOLID CORE WOOD DOOR SEE DOOR SCHEDULE FOR SIZE	
C	INTERIOR SOLID CORE WOOD DOOR SEE DOOR SCHEDULE FOR SIZE	
D	EXTERIOR HOLLOW METAL DOOR SEE DOOR SCHEDULE FOR SIZE	
E	EXISTING DOOR TO REMAIN REPAIR AS NEEDED	
F	INTERIOR METAL + GLASS GARAGE DOOR SEE DOOR SCHEDULE FOR SIZE	
G	INTERIOR WOOD POCKET DOOR GENTLEMAN DOOR AUTOMATION AIR POWERED AUTOMATIC POCKET DOOR OPENER SEE DOOR SCHEDULE FOR SIZE	
H	EXTERIOR HOLLOW METAL DOOR SEE DOOR SCHEDULE FOR SIZE	

L O C K S E T	
A	ENTRY STOREFRONT LOCKSET AT DOUBLE DOORS W/INTERNAL BOLT HEAD AND SILL
B	LOCKSET
C	PASSAGE SET
D	OVERHEAD DOOR - INTERIOR BOLT
E	EXISTING HARDWARE TO REMAIN - REPAIR AS NEEDED
F	GENTLEMAN AUTOMATIC POCKER DOOR

D O O R S C H E D U L E																	
DOOR #	LOCATION	DOOR TYPE	LOCKSET	HEIGHT	WIDTH	DOOR MATERIAL	DOOR FINISH	FRAME MATERIAL	FRAME FINISH	CLOSER	FLOOR STOP	WALL STOP	DOOR GLAZING	PANIC HARDWARE	NOTES	KICKPLATE	HINGES
101A	PREFUNCTION	A	A	7'-0"	6'-0"	ALUM. GLASS	DARK BRONZE	ALUM.	DARK BRONZE	SURF. MOUNT	NO	NO	TEMPERED	NO	NO LATCH - EGRESS DOOR	NO	(6)
101B	PREFUNCTION	B	C	7'-0"	3'-0"	WOOD	PTD.	HM	PTD.	SURF. MOUNT	NO	NO	---	---		NO	(3)
101C	PREFUNCTION	C	C	7'-0"	6'-0"	WOOD	PTD.	HM	PTD.	90° HOLD OPEN	YES	NO	---	NO		NO	(6)
101D	PREFUNCTION	C	C	7'-0"	6'-0"	WOOD	PTD.	HM	PTD.	90° HOLD OPEN	YES	NO	---	NO		NO	(6)
102	ELEC.	E	E	---	---	---	---	---	---	---	---	---	---	---		---	---
103	RESTROOM	B	B	7'-0"	3'-0"	WOOD	PTD.	HM	PTD.	SURF. MOUNT	NO	YES	---	---		NO	(3)
104	RESTROOM	B	B	7'-0"	3'-0"	WOOD	PTD.	HM	PTD.	SURF. MOUNT	NO	YES	---	---		NO	(3)
105A	CHECKIN	A	A	7'-0"	6'-0"	ALUM. GLASS	DARK BRONZE	ALUM.	DARK BRONZE	SURF. MOUNT	NO	NO	TEMPERED	NO	NO LATCH - EGRESS DOOR	NO	(6)
105B	CHECKIN	F	D	7'-6"	10'-0"	ALUM. GLASS	DARK BRONZE	ALUM.	DARK BRONZE	---	---	---	TEMPERED	---		---	---
105C	CHECKIN	B	B	7'-0"	3'-0"	WOOD	PTD.	HM	PTD.	SURF. MOUNT	NO	NO	---	---		NO	(3)
106A	COAT	E	E	---	---	---	---	---	---	---	---	---	---	---		---	---
106B	COAT	B	C	7'-0"	3'-0"	WOOD	PTD.	HM	PTD.	NO	NO	YES	---	---		NO	(3)
107	OFFICE	E	E	---	---	---	---	---	---	---	---	---	---	---		---	---
108	ELEC.	E	E	---	---	---	---	---	---	---	---	---	---	---		---	---
109	OFFICE	E	E	---	---	---	---	---	---	---	---	---	---	---		---	---
110A	BREAKROOM	B	C	7'-0"	3'-0"	WOOD	PTD.	HM	PTD.	NO	NO	YES	---	---		NO	(3)
110B	BREAKROOM	B	C	7'-0"	3'-0"	WOOD	PTD.	HM	PTD.	NO	NO	NO	---	---		NO	(3)
111	RESTROOM	E	E	---	---	---	---	---	---	---	---	---	---	---		---	---
112	RESTROOM	E	E	---	---	---	---	---	---	---	---	---	---	---		---	---
113	OFFICE	E	E	---	---	---	---	---	---	---	---	---	---	---		---	---
114	OFFICE	E	E	---	---	---	---	---	---	---	---	---	---	---		---	---
115	OFFICE	E	E	---	---	---	---	---	---	---	---	---	---	---		---	---
116	OFFICE	E	E	---	---	---	---	---	---	---	---	---	---	---		---	---
117A	MULTIPURPOSE	B	C	7'-0"	3'-0"	WOOD	PTD.	HM	PTD.	SURF. MOUNT	NO	YES	---	---		NO	(3)
117B	MULTIPURPOSE	E	E	---	---	---	---	---	---	---	---	---	---	---		---	---
118	UTILITY	B	B	7'-0"	3'-0"	WOOD	PTD.	HM	PTD.	SURF. MOUNT	NO	YES	---	---		NO	(3)
119	RESTROOM	B	B	7'-0"	3'-0"	WOOD	PTD.	HM	PTD.	SURF. MOUNT	NO	YES	---	---		NO	(3)
120	STORAGE	E	E	---	---	---	---	---	---	---	---	---	---	---	REWORK EXISTING FRAME FOR SINGLE DOOR	---	---
121A	KITCHEN	C	C	7'-0"	5'-0"	WOOD	PTD.	HM	PTD.	SURF. MOUNT	NO	YES	---	---		NO	(6)
121B	CATERING KITCHEN	C	C	7'-0"	6'-0"	WOOD	PTD.	HM	PTD.	SURF. MOUNT	NO	NO	---	---		NO	(6)
122	ELEC.	E	E	---	---	---	---	---	---	---	---	---	---	---		---	---
123	PRODUCTION	B	B	7'-0"	3'-0"	WOOD	PTD.	HM	PTD.	SURF. MOUNT	NO	NO	---	---		NO	(3)
124	RESTROOM	G	F	7'-0"	3'-0"	WOOD	PTD.	HM	PTD.	CONCEALED	---	---	---	---		NO	---
125	RESTROOM	G	F	7'-0"	3'-0"	WOOD	PTD.	HM	PTD.	CONCEALED	---	---	---	---		NO	---
126A	BALLROOM	C	C	7'-0"	6'-0"	WOOD	PTD.	HM	PTD.	SURF. MOUNT	YES	NO	---	NO		NO	(6)
126B	BALLROOM	C	C	7'-0"	6'-0"	WOOD	PTD.	HM	PTD.	SURF. MOUNT	YES	NO	---	NO		NO	(6)
126C	BALLROOM	B	C	7'-0"	3'-0"	WOOD	PTD.	HM	PTD.	SURF. MOUNT	NO	NO	---	NO		NO	(3)
126D	BALLROOM	B	C	7'-0"	3'-0"	WOOD	PTD.	HM	PTD.	SURF. MOUNT	NO	NO	---	NO		NO	(3)
126E	BALLROOM	B	C	7'-0"	3'-0"	WOOD	PTD.	HM	PTD.	SURF. MOUNT	NO	NO	---	NO		NO	(3)
126F	BALLROOM	E	E	---	---	---	---	---	---	---	---	---	---	---		---	---
127A	WAREHOUSE	E	E	---	---	---	---	---	---	---	---	---	---	---		---	---
127B	WAREHOUSE	C	B	7'-0"	6'-0"	WOOD	PTD.	HM	PTD.		NO	YES	---	---		NO	(6)
128A	WAREHOUSE	C	B	7'-0"	6'-0"	WOOD	PTD.	HM	PTD.		NO	YES	---	---		NO	(6)
128B	WAREHOUSE	E	E	---	---	---	---	---	---	---	---	---	---	---		---	---
128C	WAREHOUSE	E	E	---	---	---	---	---	---	---	---	---	---	---		---	---
129A	CORRIDOR	D	A	7'-0"	3'-0"	HM	PTD.	HM	PTD.	SURF. MOUNT	NO	NO	---	NO		NO	(3)
129B	CORRIDOR	H	A	7'-0"	6'-0"	HM	PTD.	HM	PTD.	SURF. MOUNT	YES	NO	---	NO		NO	(6)
129C	CORRIDOR	E	E	---	---	---	---	---	---	---	---	---	---	---		---	---
130	STORAGE	C	B	7'-0"	6'-0"	WOOD	PTD.	HM	PTD.		NO	YES	---	---		NO	(6)
131A	STORAGE	C	B	7'-0"	6'-0"	WOOD	PTD.	HM	PTD.		NO	YES	---	---		NO	(6)
131B	STORAGE	F	D	10'-0"	8'-0"	ALUM. GLASS	DARK BRONZE	ALUM.	DARK BRONZE	---	---	---	TEMPERED	---	OPAQUE FROSTED GLASS	---	---
131C	STORAGE	E	E	---	---	---	---	---	---	---	---	---	---	---		---	---
132	STORAGE	B	B	7'-0"	3'-0"	WOOD	PTD.	HM	PTD.	SURF. MOUNT	NO	NO	---	---		NO	(3)
133A	STORAGE	B	B	7'-0"	3'-0"	WOOD	PTD.	HM	PTD.	SURF. MOUNT	NO	NO	---	---		NO	(3)
133B	STORAGE	E	E	---	---	---	---	---	---	---	---	---	---	---		---	---

A1.08

DOOR SCHEDULE

1/8" = 1'-0"

ISSUED
01/24/22 PRELIMINARY
XX XXXX PERMIT SET

ONE STOP PRODUCTIONS

1333 Logan Circle NW
Atlanta, GA 30318

Project Number: 777.00

ISSUED FOR
PERMIT & CONSTRUCTION

Selig Enterprises
6595 ROSWELL ROAD, SUITE G
ATLANTA, GA 30328

STRUCTURAL

Kelly Albright
PEC Structural Engineering
2752 East Ponce de Leon Ave
Suite D
Atlanta, Georgia 30030
404.660.6022

M.E.P. & F.P.


Westside Engineering
5525 Intestate North Parkway
Suite 200
Atlanta, GA 30328
Phone: 404-242-6240

CIVIL

STATE OF GEORGIA
ERIK W. LEWITT
REGISTERED ARCHITECT


plexus r + d, Inc.
914 Howell Mill Road, Suite 400 - Atlanta, Georgia 30318
404.519.7728 PHONE

© COPYRIGHT 2022 - PLEXUS R + D, INC.

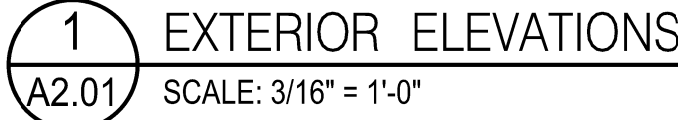


CONTRACTOR
STRUCTURAL
Kelly Albright PEC Structural Engineering 2752 East Ponce de Leon Ave Suite D Atlanta, Georgia 30030 404.660.6022
M.E.P. & F.P.
Westside Engineering 5525 Interstate North Parkway Suite 200 Atlanta, GA 30328 Phone: 404-242-6240
CIVIL


plexus r + d, Inc.
1714 Howell Mill Road, Suite 400 - Atlanta, Georgia 30318
404.519.7728 PHONE

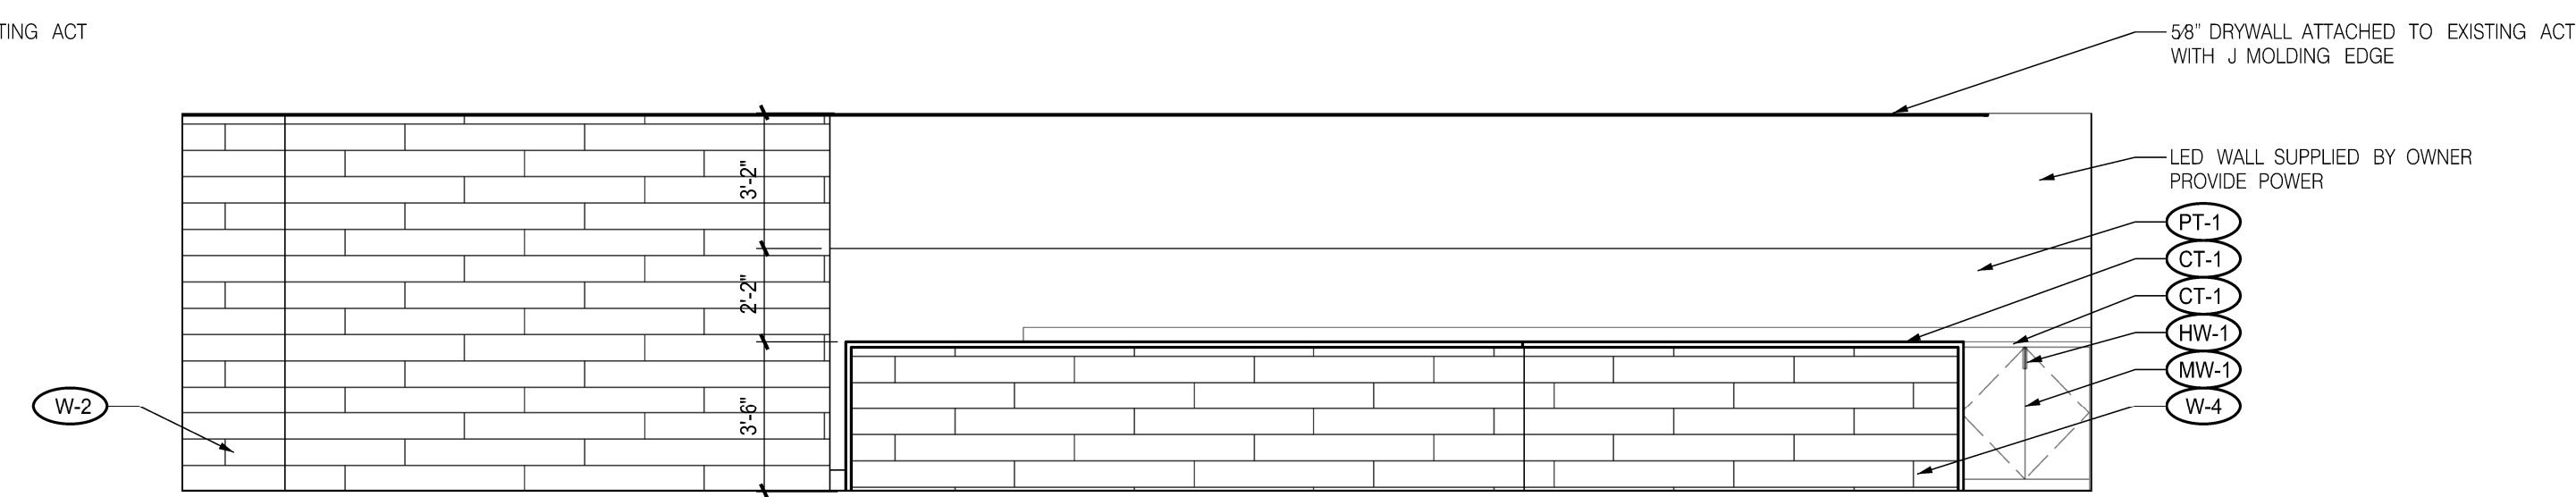


2 INTERIOR ELEVATION – PREFUNCTION
A4.01 SCALE: 1/4" = 1'-0"

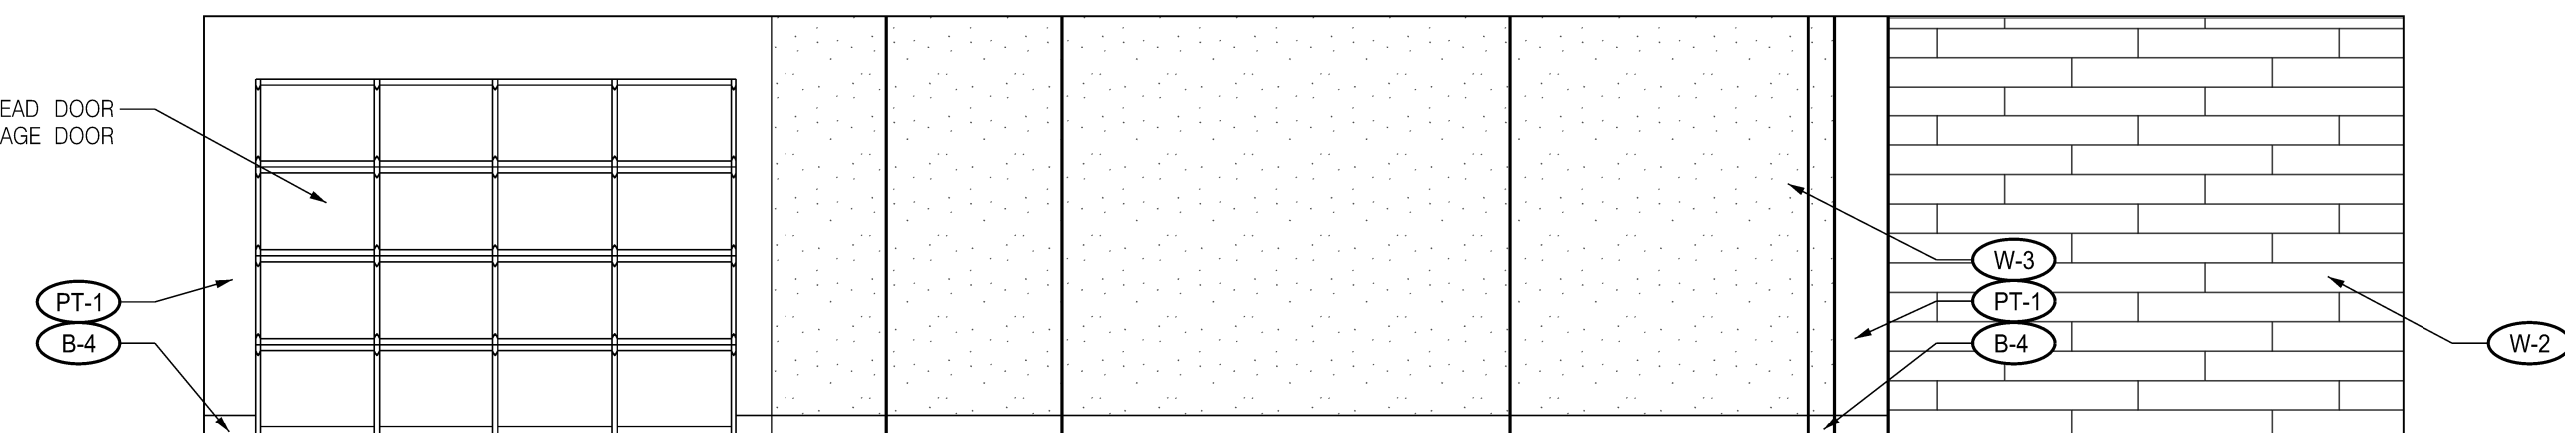


4 INTERIOR ELEVATION - PREFUNCTION
A4.01 SCALE: 1/4" = 1'-0"

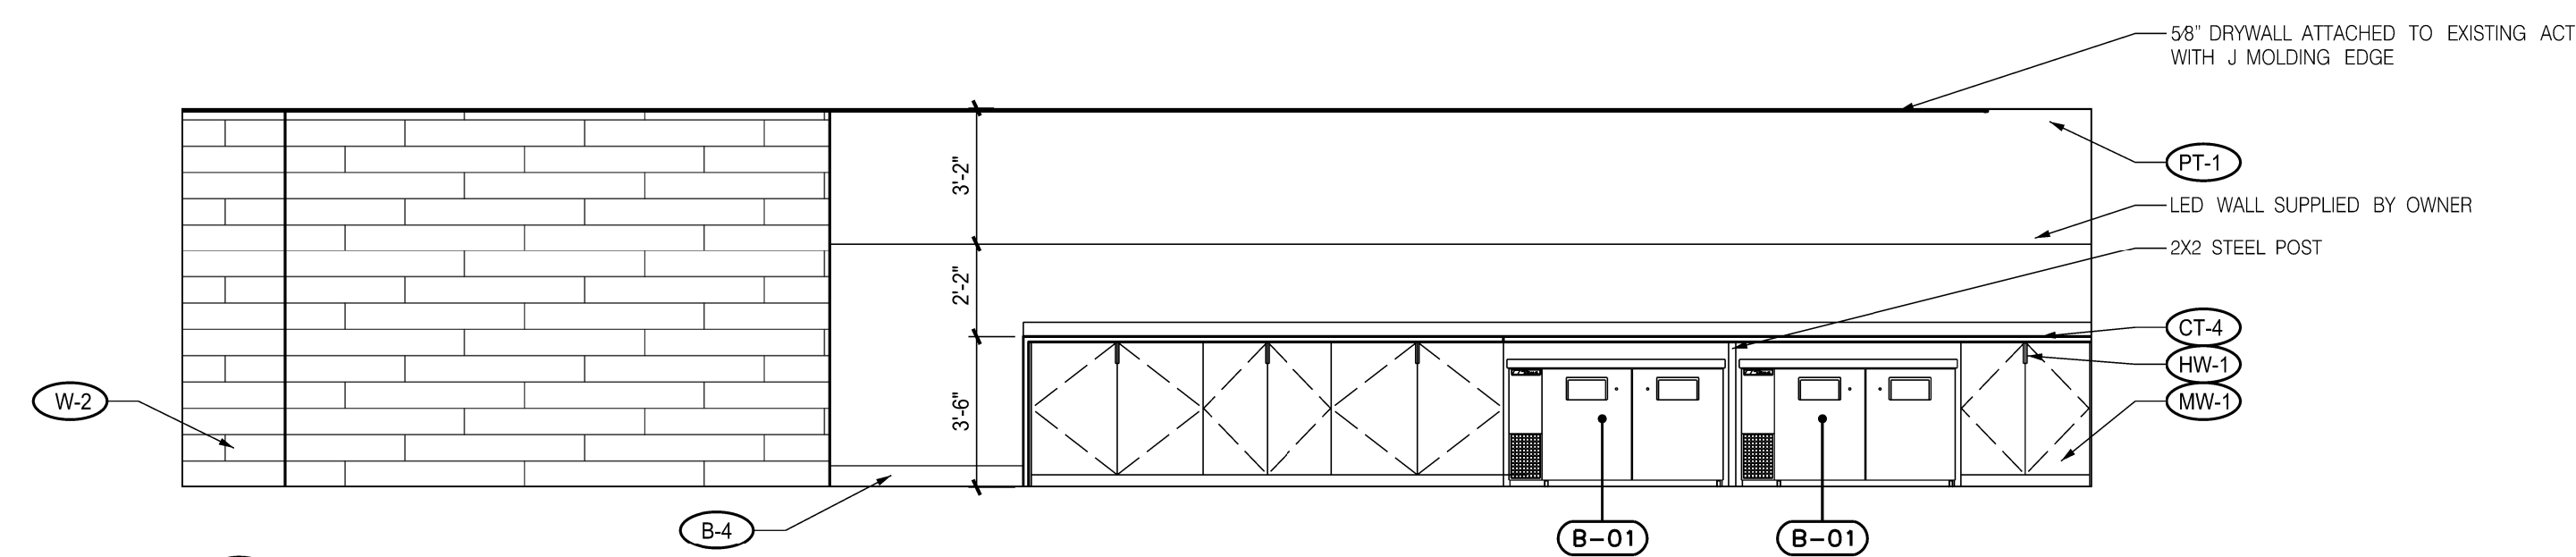

6 INTERIOR ELEVATION – PREFUNCTION
A4.01 SCALE: 1/4" = 1'-0"

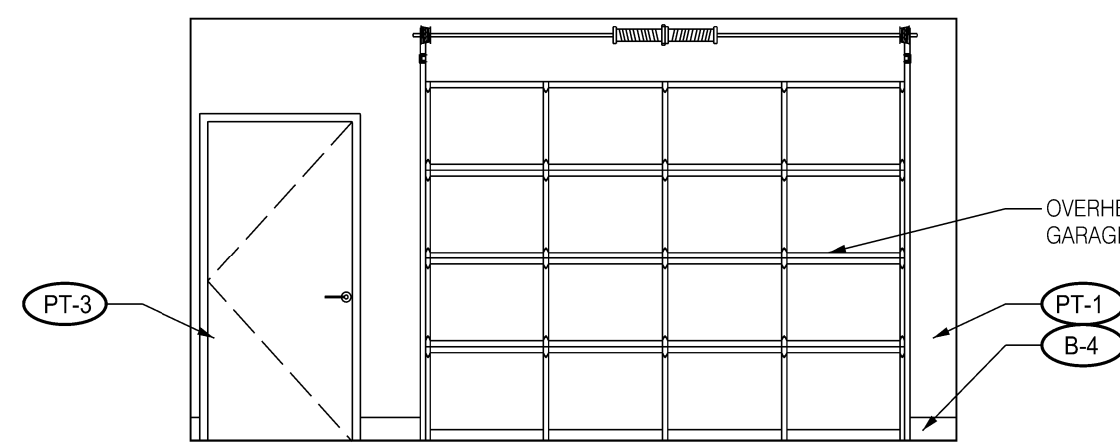

9 INTERIOR ELEVATION - CHECKIN
A4.01 SCALE: 1/4" = 1'-0"

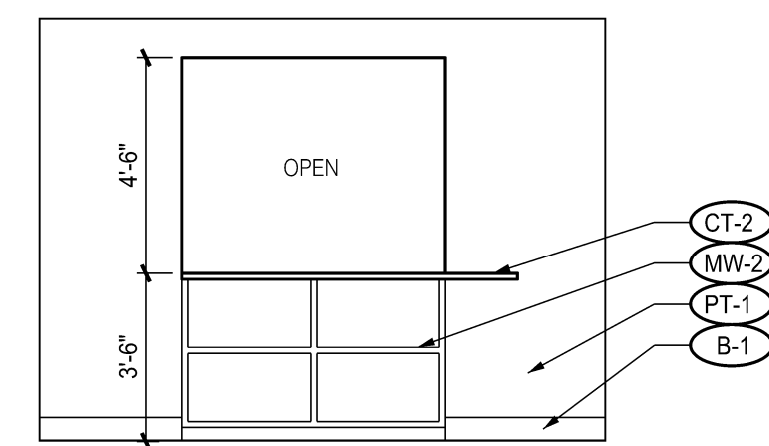

11 INTERIOR ELEVATION - CHECKIN
A4.01 SCALE: 1/4" = 1'-0"

ISSUED	
01/24/22	PRELIMINARY
XX/XX/XX	PERMIT SET

ONE STOP PRODUCTIONS

1333 Logan Circle NW
Atlanta, GA 30318

Project Number: 777.00	Selig Enterprises 6595 ROSWELL ROAD, SUITE G ATLANTA, GA 30328
ISSUED FOR PERMIT & CONSTRUCTION	

CONTRACTOR


STRUCTURAL

Kelly Allbright
PEC Structural Engineering
2752 East Ponce de Leon Ave
Suite D
Atlanta, Georgia 30030
404.660.6022

M.E.P. & F.P.

Westside Engineering
5525 Interstate North Parkway
Suite 200
Atlanta, GA 30328
Phone: 404-242-6240

CIVIL

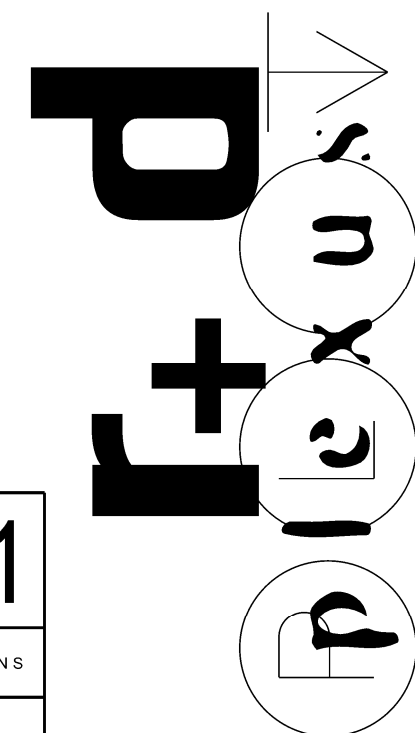


plexus r + d, Inc.
914 Howell Mill Road, Suite 400 - Atlanta, Georgia 30318
404.519.7728 PHONE

© COPYRIGHT 2022 - PLEXUS R + D, INC.


A4.01

INTERIOR ELEVATIONS


$$1/4" = 1'-0"$$

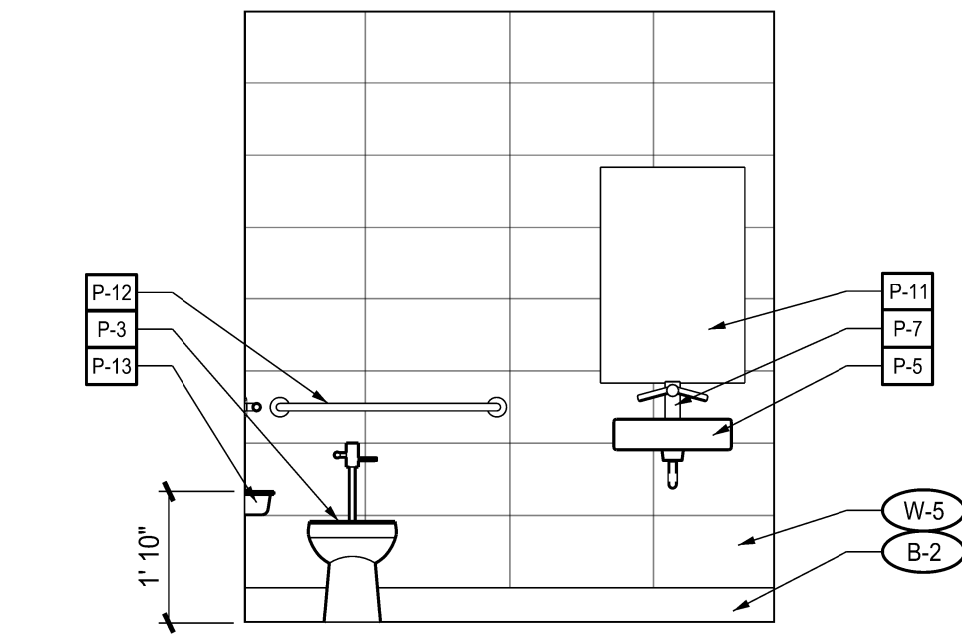


1 INTERIOR ELEVATION – RESTROOM
A4.02 SCALE: 3/8" = 1'-0"

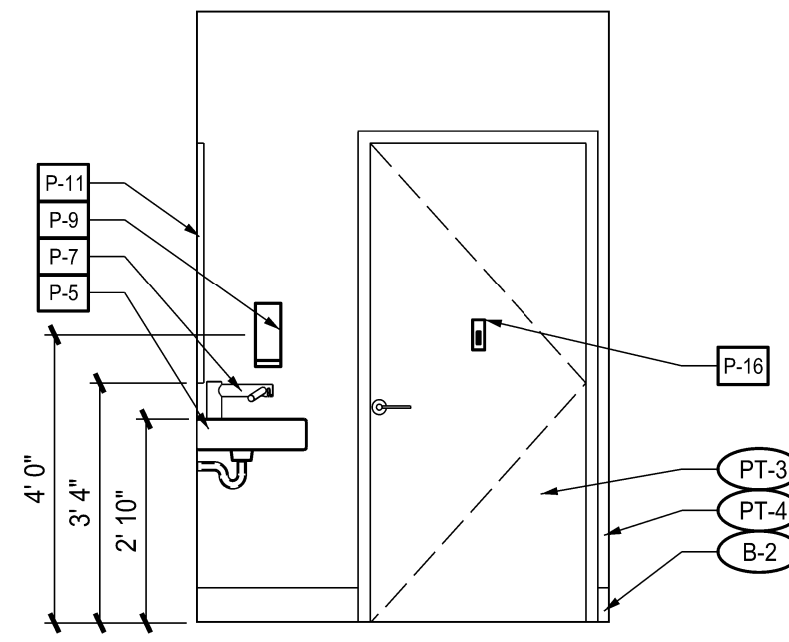


2 INTERIOR ELEVATION – RESTROOM
A4.02 SCALE: 3/8" = 1'-0"

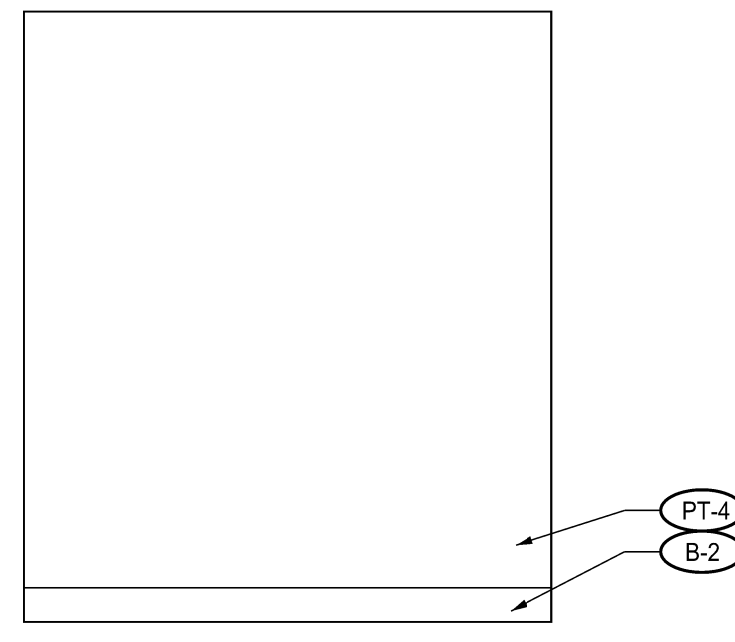


3 INTERIOR ELEVATION – RESTROOM
A4.02 SCALE: 3/8" = 1'-0"

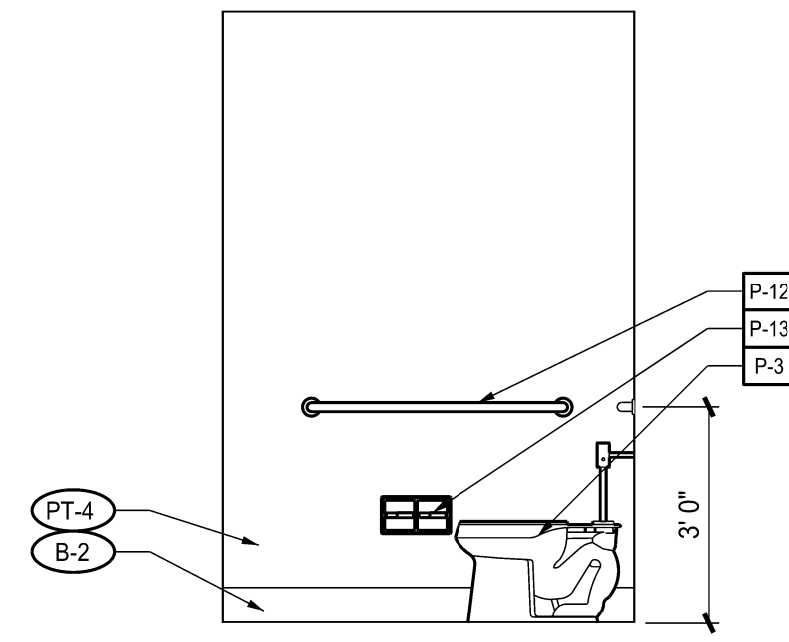


4 INTERIOR ELEVATION – RESTROOM
A4.02 SCALE: 3/8" = 1'-0"

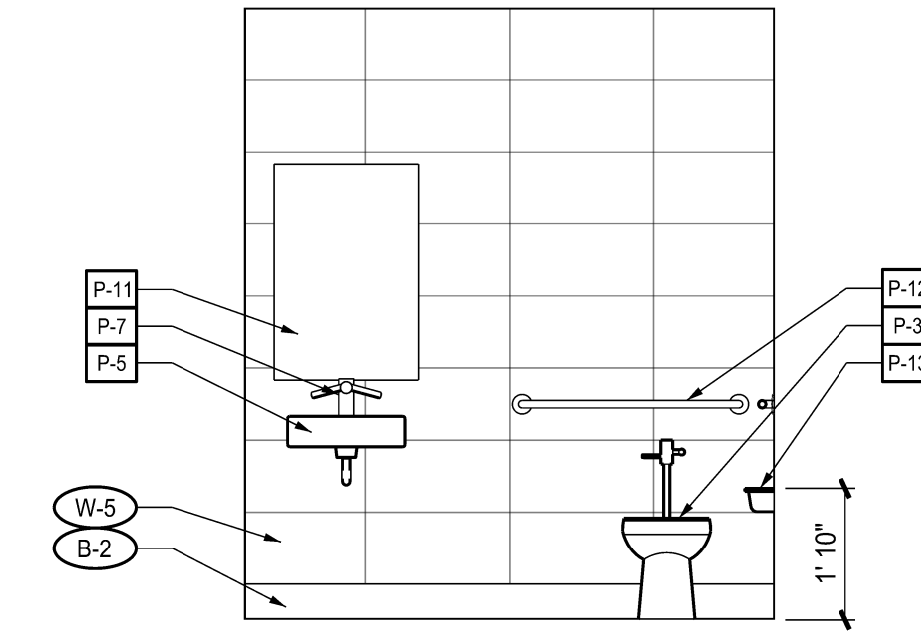


5 INTERIOR ELEVATION – RESTROOM
A4.02 SCALE: 3/8" = 1'-0"

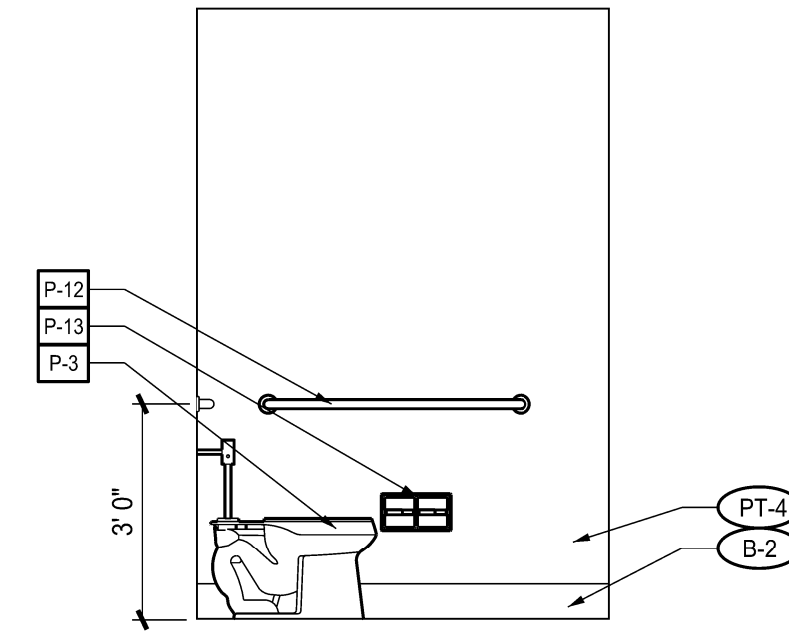


6 INTERIOR ELEVATION – RESTROOM
A4.02 SCALE: 3/8" = 1'-0"

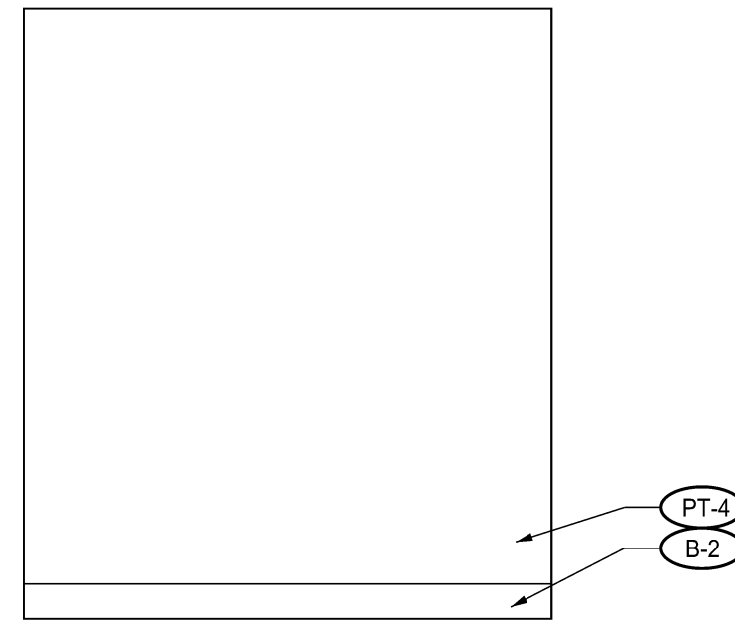


7 INTERIOR ELEVATION – RESTROOM
A4.02 SCALE: 3/8" = 1'-0"

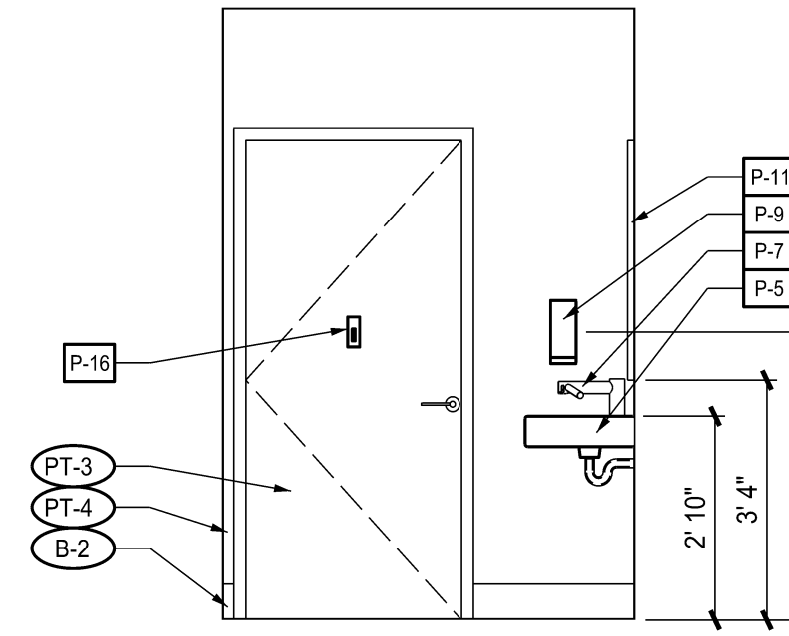

8 INTERIOR ELEVATION – RESTROOM
A4.02 SCALE: 3/8" = 1'-0"

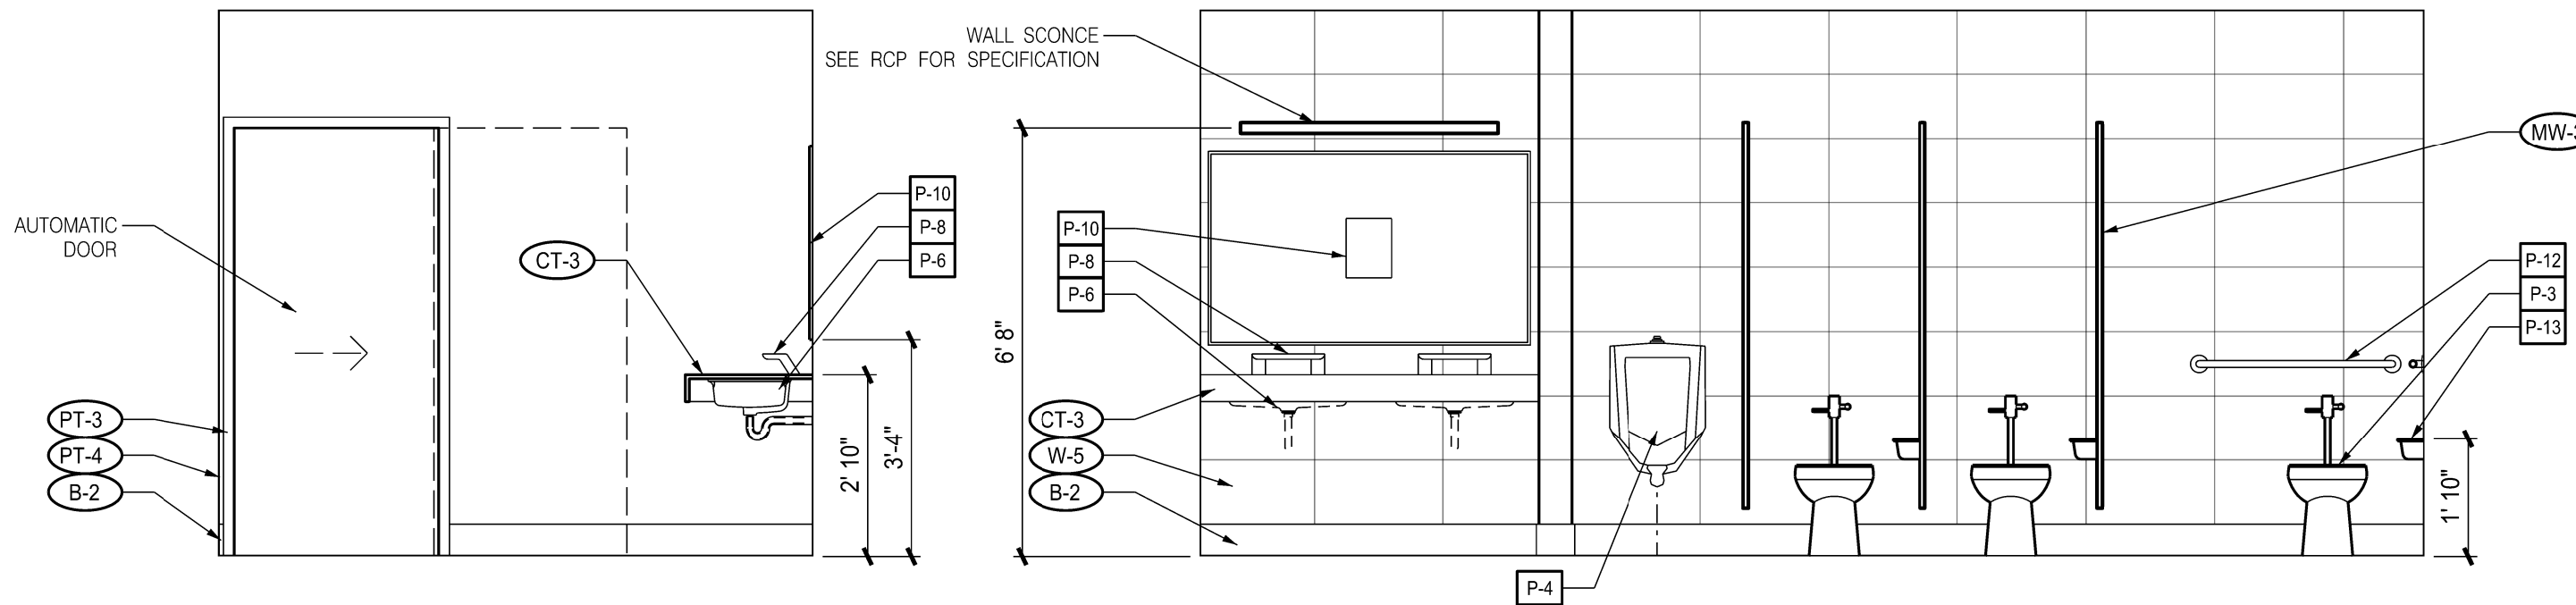


9 INTERIOR ELEVATION – RESTROOM
A4.02 SCALE: 3/8" = 1'-0"

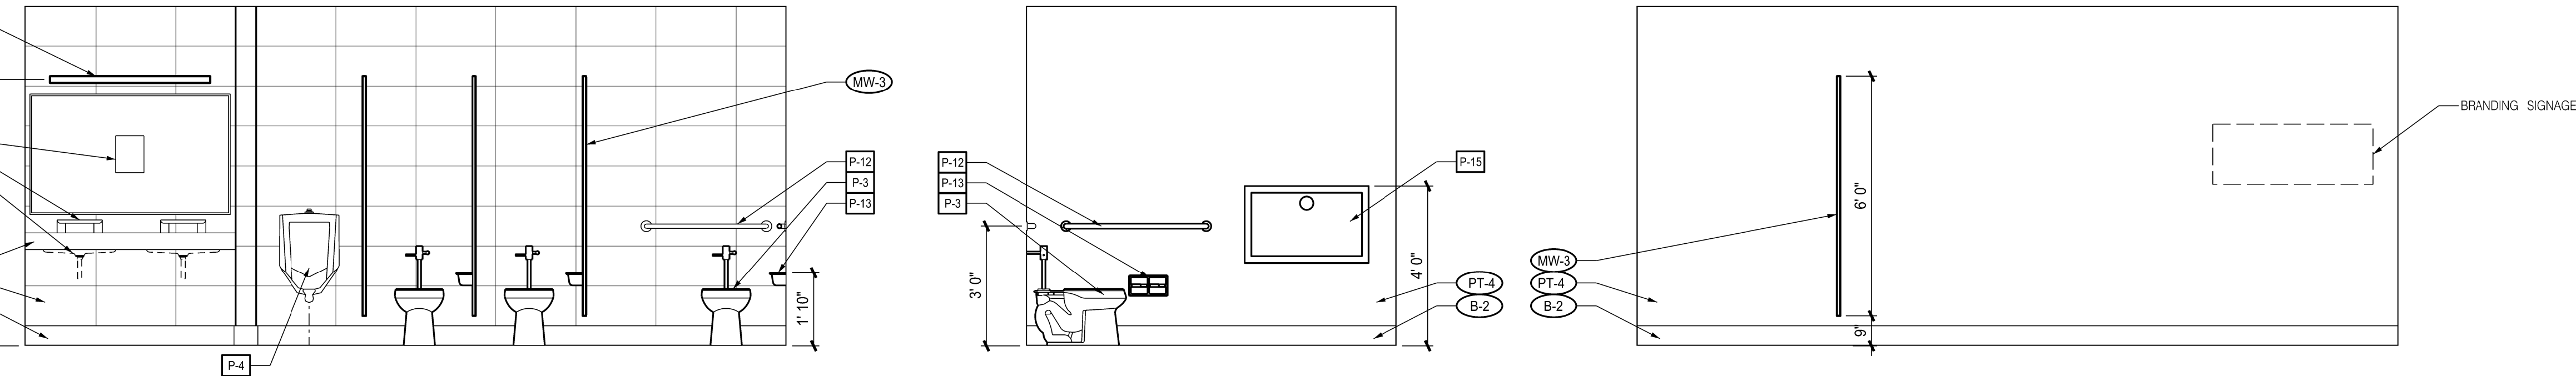


10 INTERIOR ELEVATION – RESTROOM
A4.02 SCALE: 3/8" = 1'-0"

11 INTERIOR ELEVATION – RESTROOM
A4.02 SCALE: 3/8" = 1'-0"


12 INTERIOR ELEVATION – RESTROOM
A4.02 SCALE: 3/8" = 1'-0"

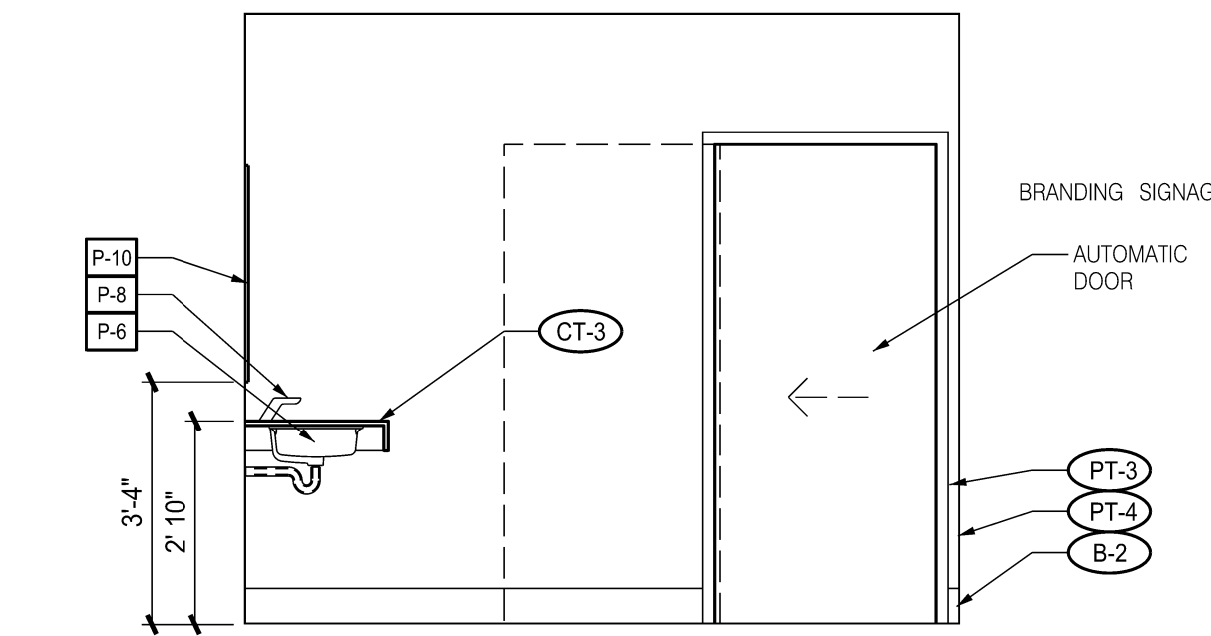


13 INTERIOR ELEVATION – RESTROOM
A4.02 SCALE: 3/8" = 1'-0"

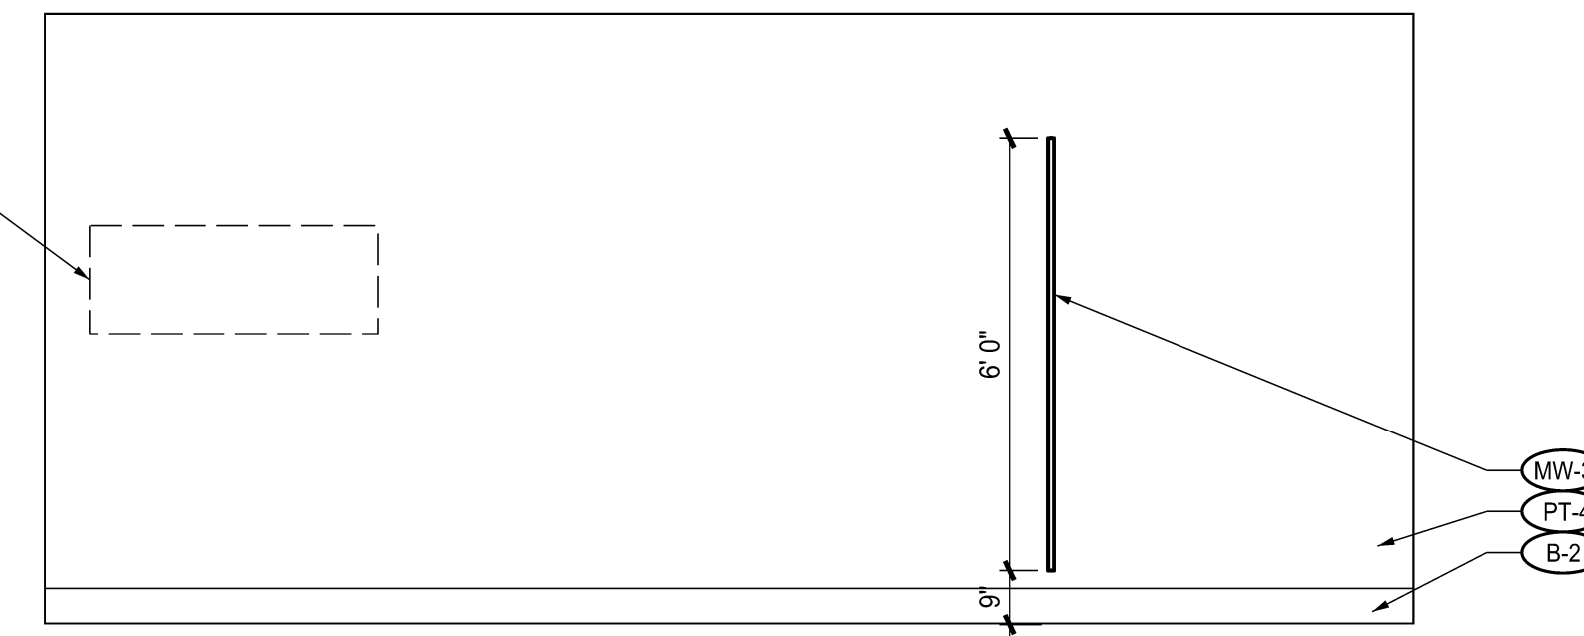

14 INTERIOR ELEVATION – RESTROOM
A4.02 SCALE: 3/8" = 1'-0"

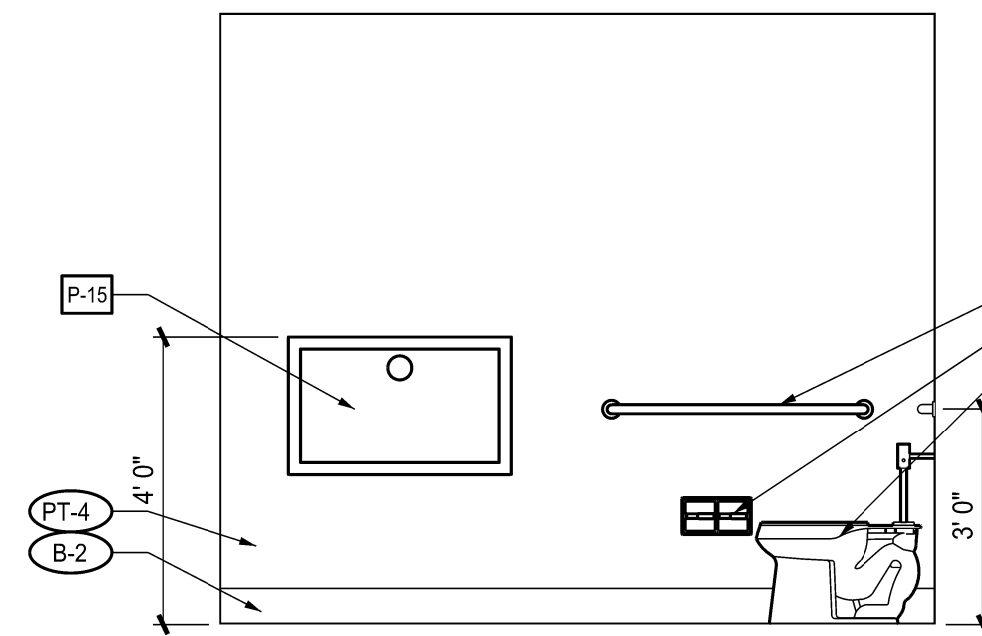

15 INTERIOR ELEVATION – RESTROOM
A4.02 SCALE: 3/8" = 1'-0"

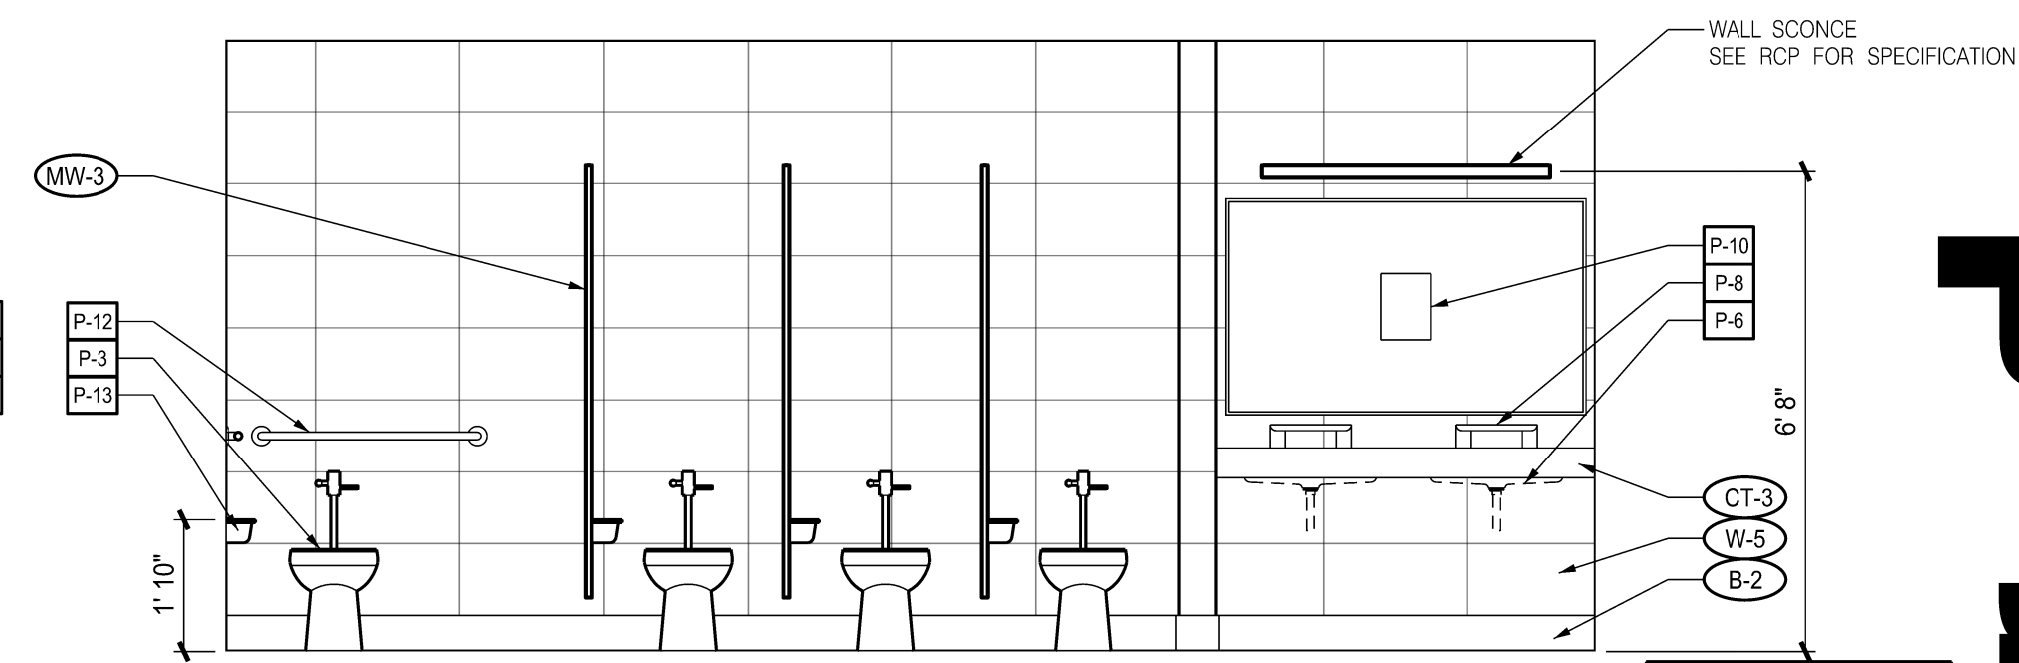


16 INTERIOR ELEVATION – RESTROOM
A4.02 SCALE: 3/8" = 1'-0"

A4.02
INTERIOR ELEVATIONS
3/8" = 1'-0"


ISSUED
01/24/22 PRELIMINARY
XX XXXX PERMIT SET

ONE STOP PRODUCTIONS 1333 Logan Circle NW Atlanta, GA 30318	
Project Number: 777.00	Selig Enterprises 6595 ROSWELL ROAD, SUITE G ATLANTA, GA 30328
ISSUED FOR	PERMIT & CONSTRUCTION


CONTRACTOR
STRUCTURAL Kelly Allbright PEC Structural Engineering 2752 East Ponce de Leon Ave Suite D Atlanta, Georgia 30030 404.660.6022
M.E.P. & F.P. Westside Engineering 5525 Intestate North Parkway Suite 200 Atlanta, GA 30328 Phone: 404-242-6240
CIVIL

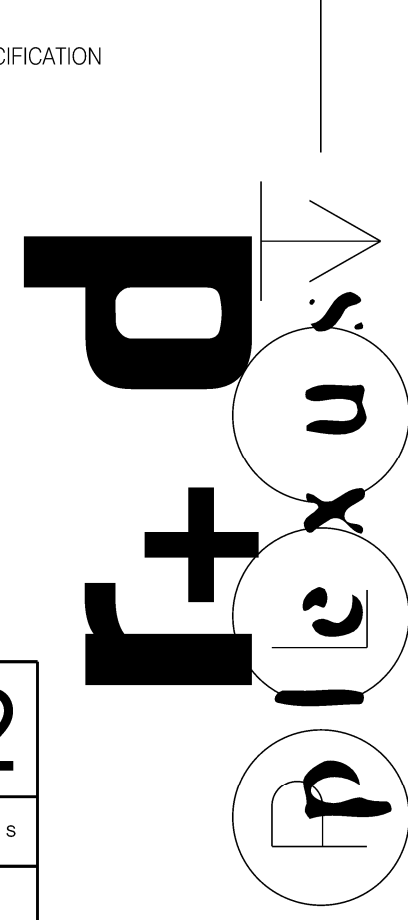


plexus r + d, Inc.
914 Howell Mill Road, Suite 400 - Atlanta, Georgia 30318
404.519.7728 PHONE
© COPYRIGHT 2022 - PLEXUS R + D, INC.

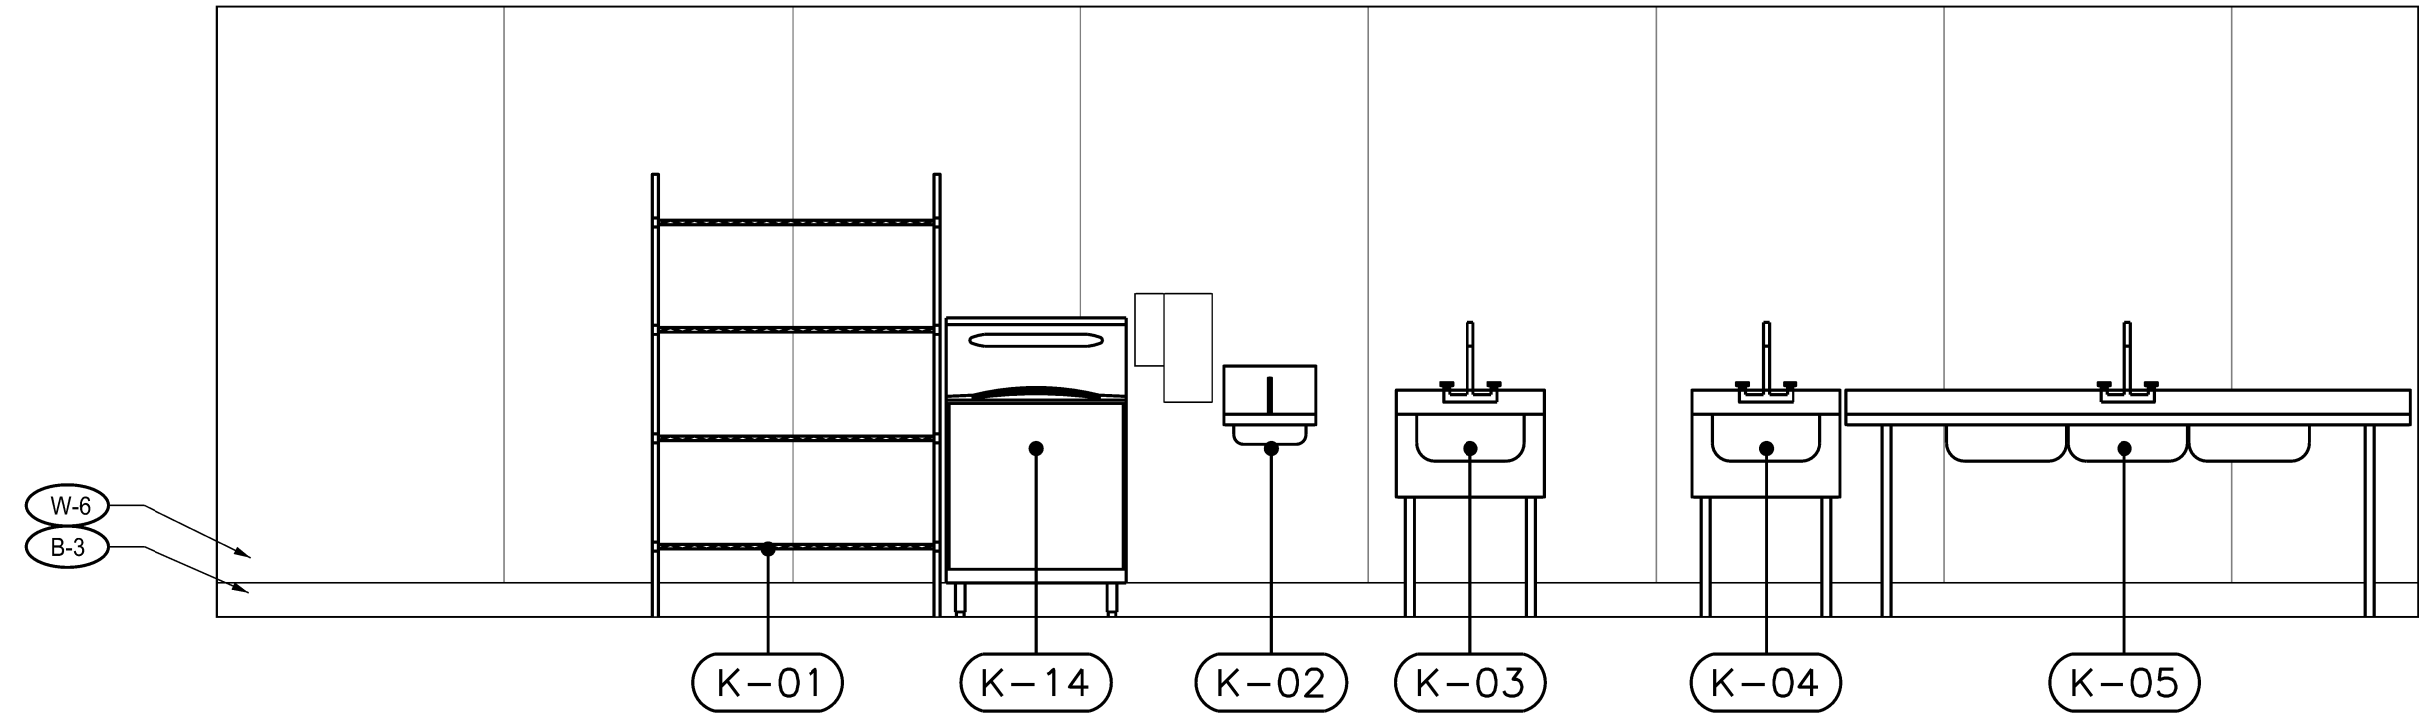


1 INTERIOR ELEVATION – KITCHEN
A4.03 SCALE: 3/8" = 1'-0"

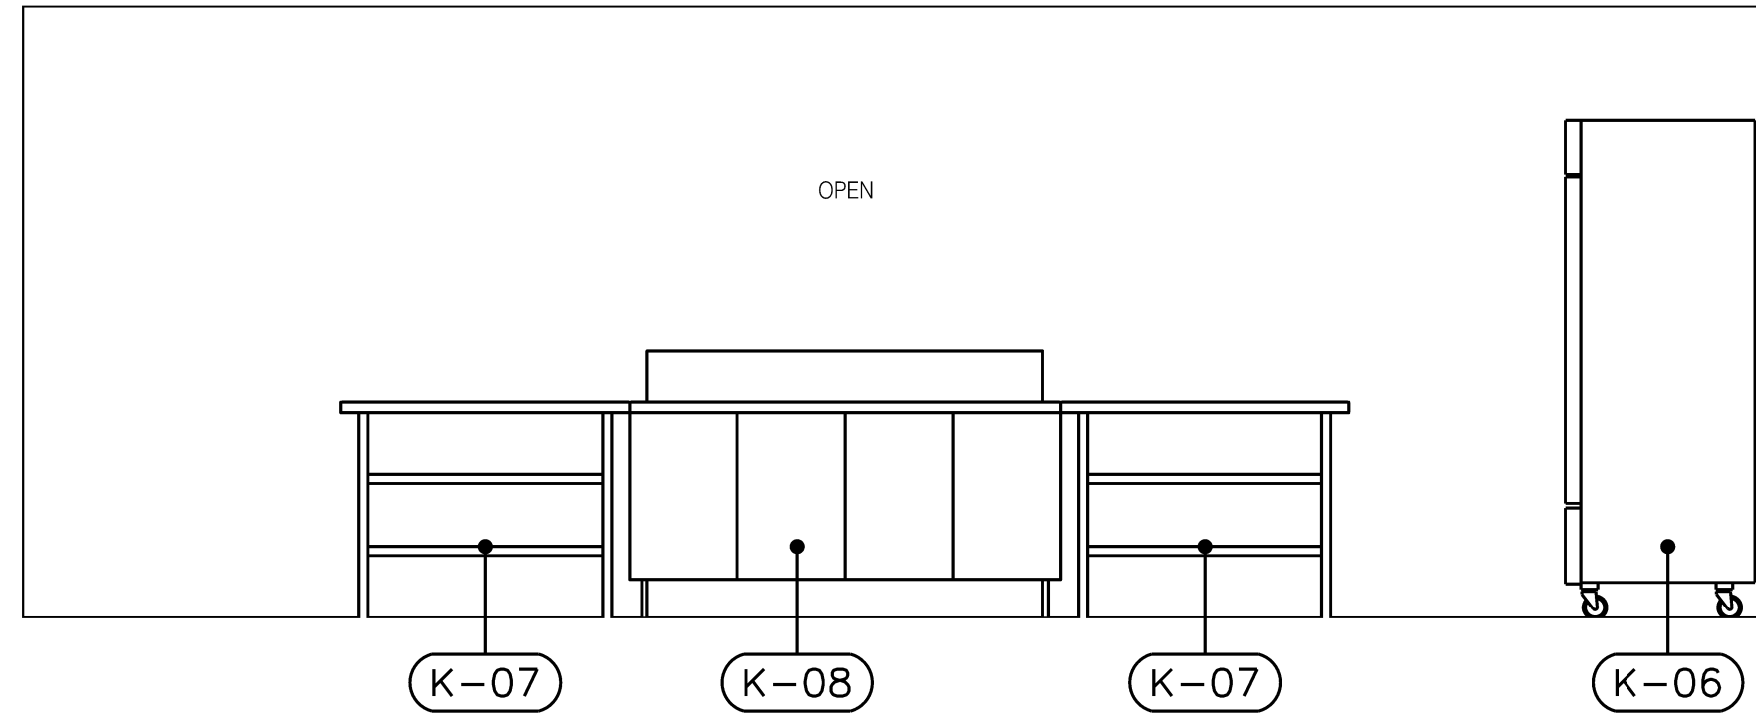


2 INTERIOR ELEVATION – KITCHEN
A4.03 SCALE: 3/8" = 1'-0"

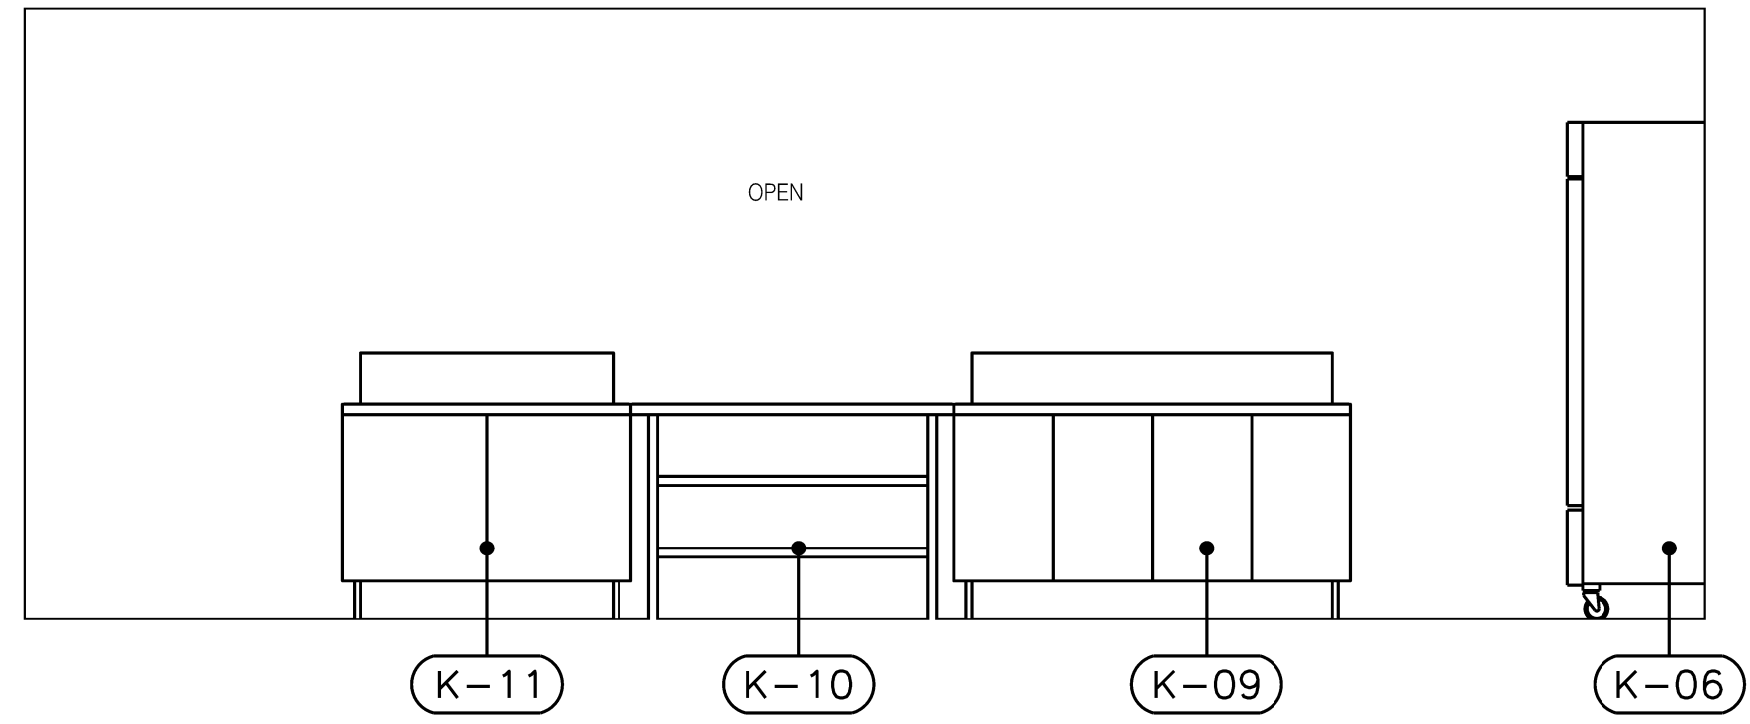


3 INTERIOR ELEVATION – KITCHEN
A4.03 SCALE: 3/8" = 1'-0"

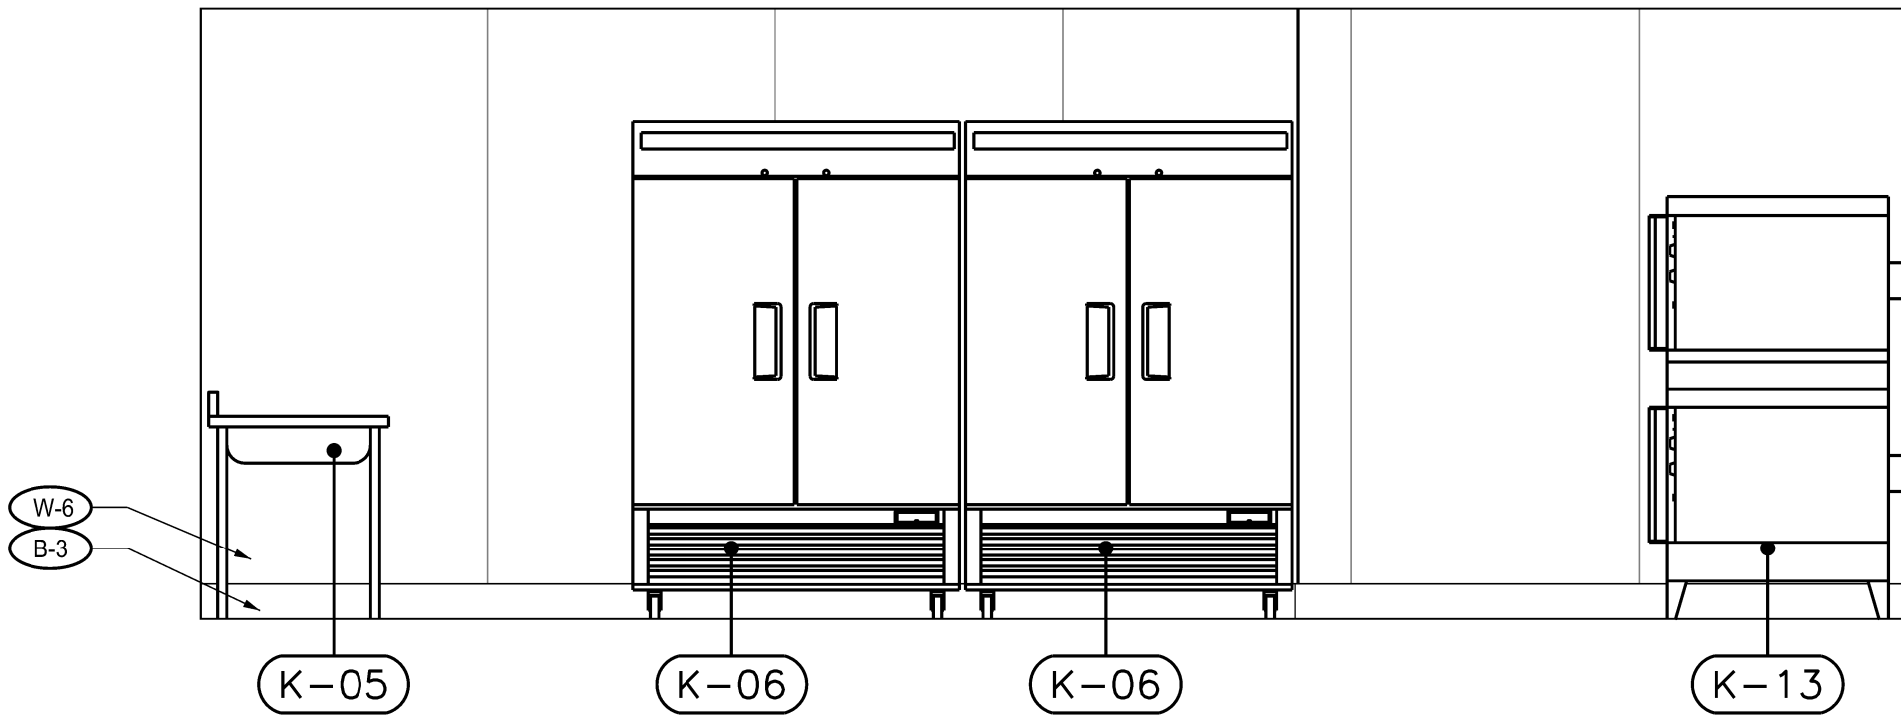


4 INTERIOR ELEVATION – KITCHEN
A4.03 SCALE: 3/8" = 1'-0"

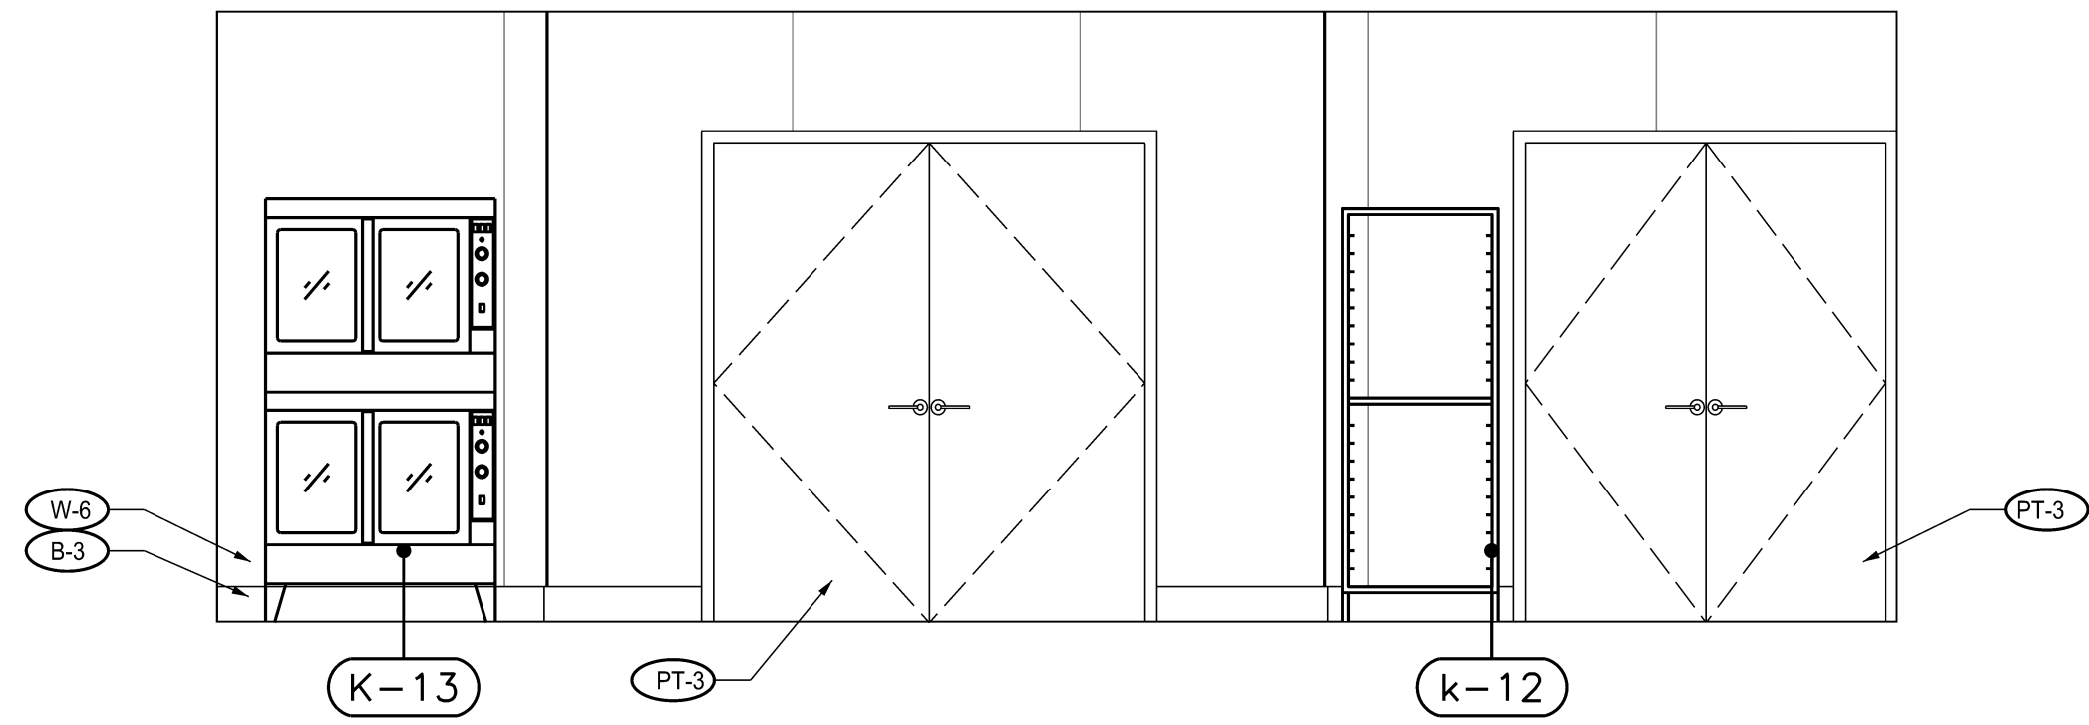


5 INTERIOR ELEVATION – KITCHEN
A4.03 SCALE: 3/8" = 1'-0"

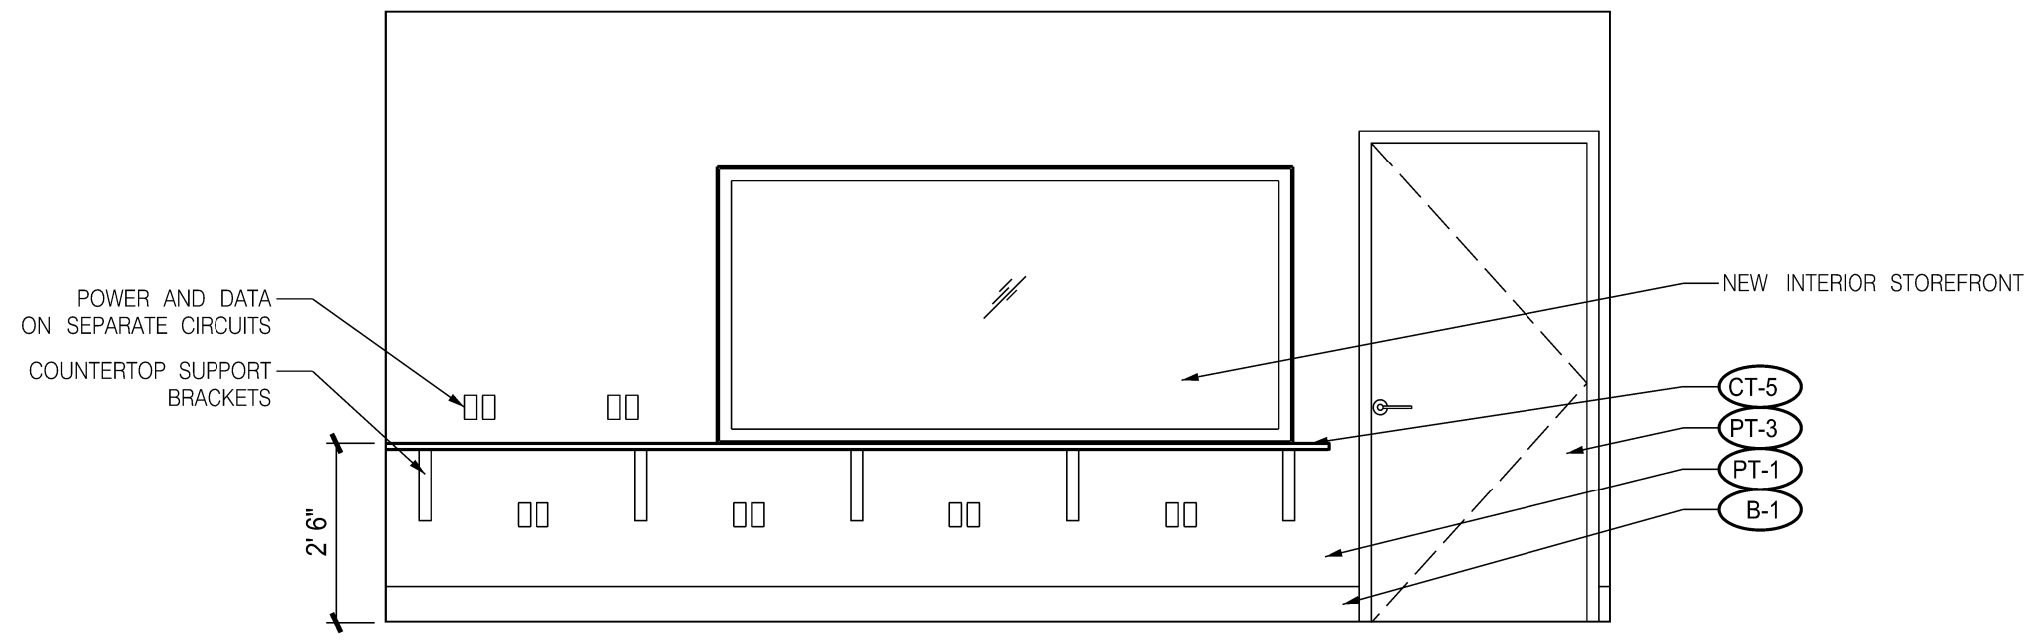


6 INTERIOR ELEVATION – PRODUCTION
A4.03 SCALE: 3/8" = 1'-0"

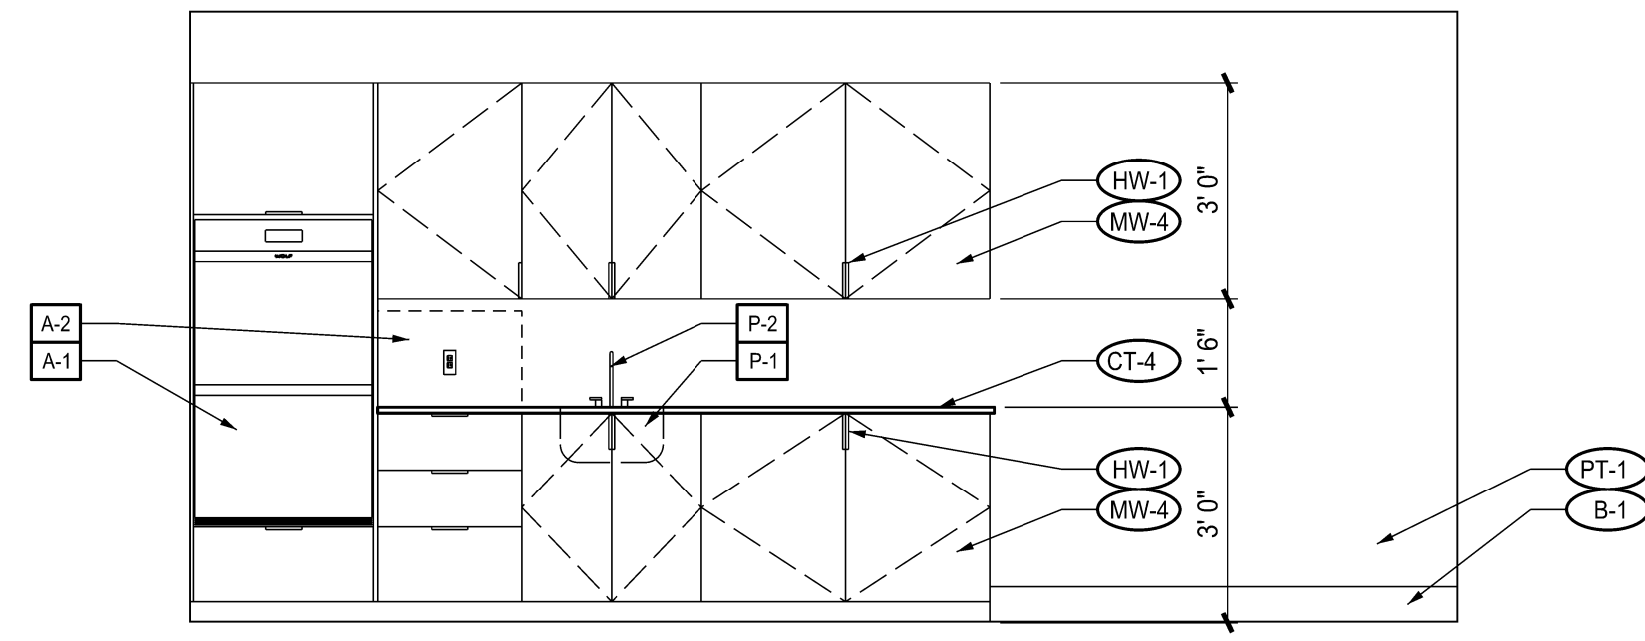


7 INTERIOR ELEVATION – BREAKROOM
A4.03 SCALE: 3/8" = 1'-0"

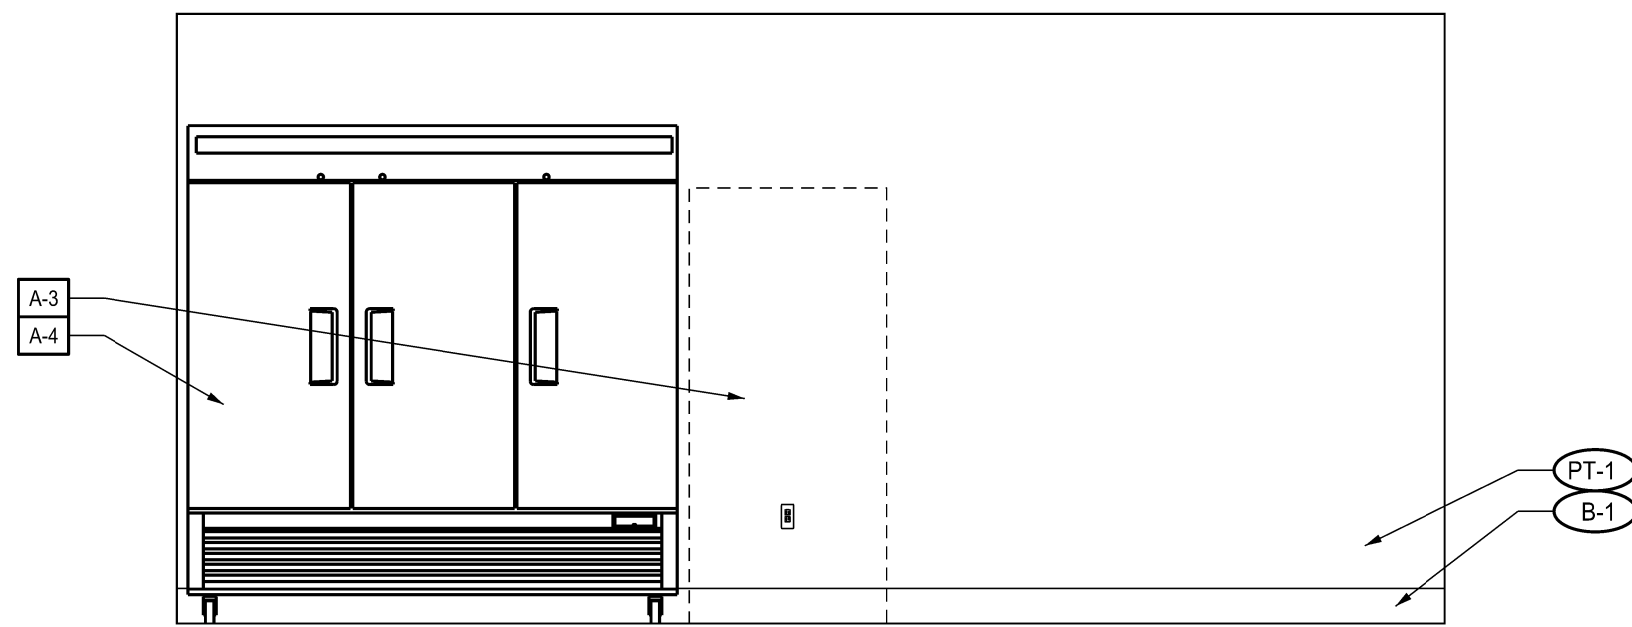


8 INTERIOR ELEVATION – BREAKROOM
A4.03 SCALE: 3/8" = 1'-0"

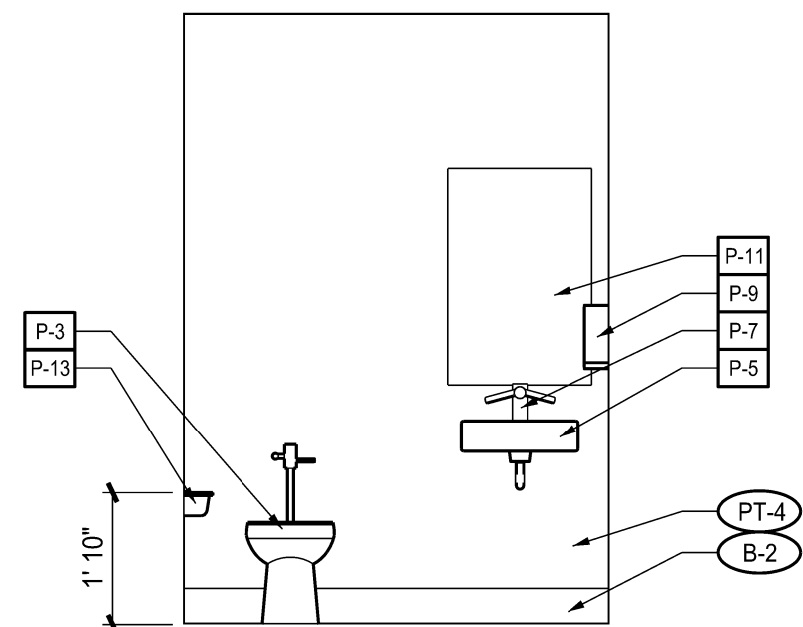

9 INTERIOR ELEVATION – RESTROOM
A4.03 SCALE: 3/8" = 1'-0"

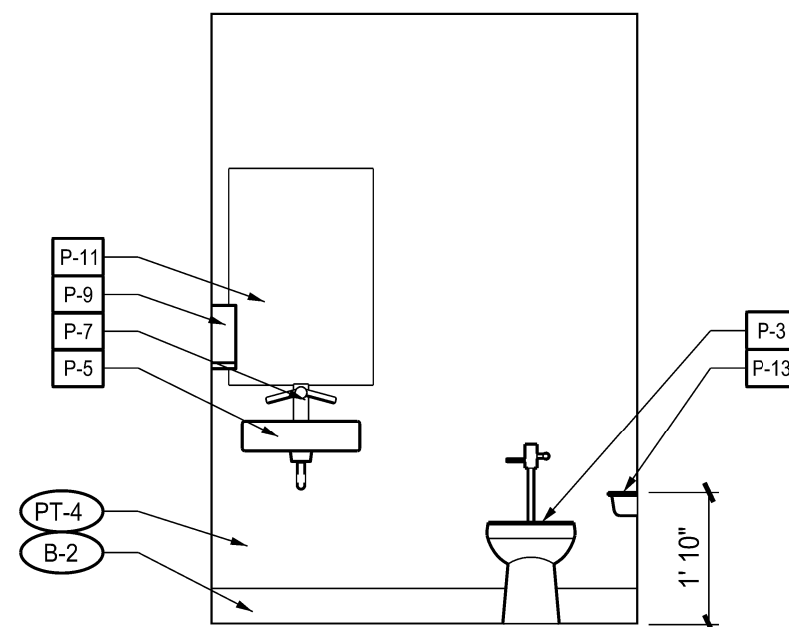

10 INTERIOR ELEVATION – RESTROOM
A4.03 SCALE: 3/8" = 1'-0"

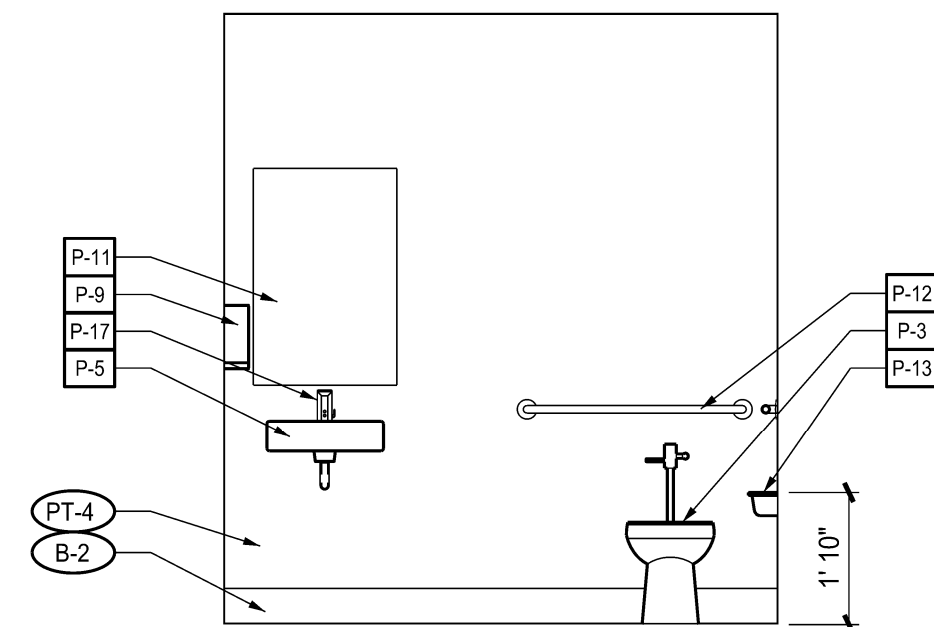


11 INTERIOR ELEVATION – RESTROOM
A4.03 SCALE: 3/8" = 1'-0"

A4.03
INTERIOR ELEVATIONS
3/8" = 1'-0"

ISSUED
01/24/22 PRELIMINARY
XX/XX/XX PERMIT SET

ONE STOP PRODUCTIONS 1333 Logan Circle NW Atlanta, GA 30318	Selig Enterprises 6595 ROSWELL ROAD, SUITE G ATLANTA, GA 30328	
	Project Number: 777.00	ISSUED FOR PERMIT & CONSTRUCTION

CONTRACTOR
STRUCTURAL Kelly Albright PEC Structural Engineering 2752 East Ponce de Leon Ave Suite D Atlanta, Georgia 30030 404.660.6022
M.E.P. & F.P. Westside Engineering 5525 Interstate North Parkway Suite 200 Atlanta, GA 30328 Phone: 404-242-6240
CIVIL

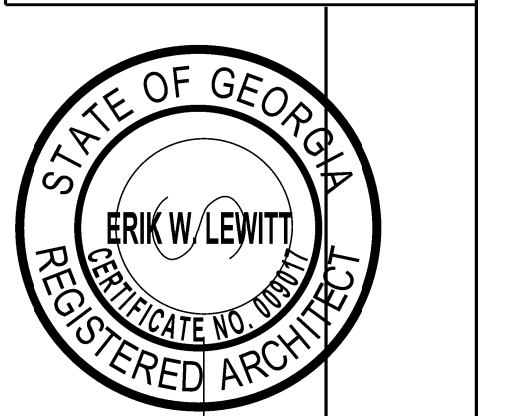

plexus r + d, inc.
914 Howell Mill Road, Suite 400 - Atlanta, Georgia 30318
404.519.7728 PHONE
© COPYRIGHT 2022 - PLEXUS R + D, INC.